


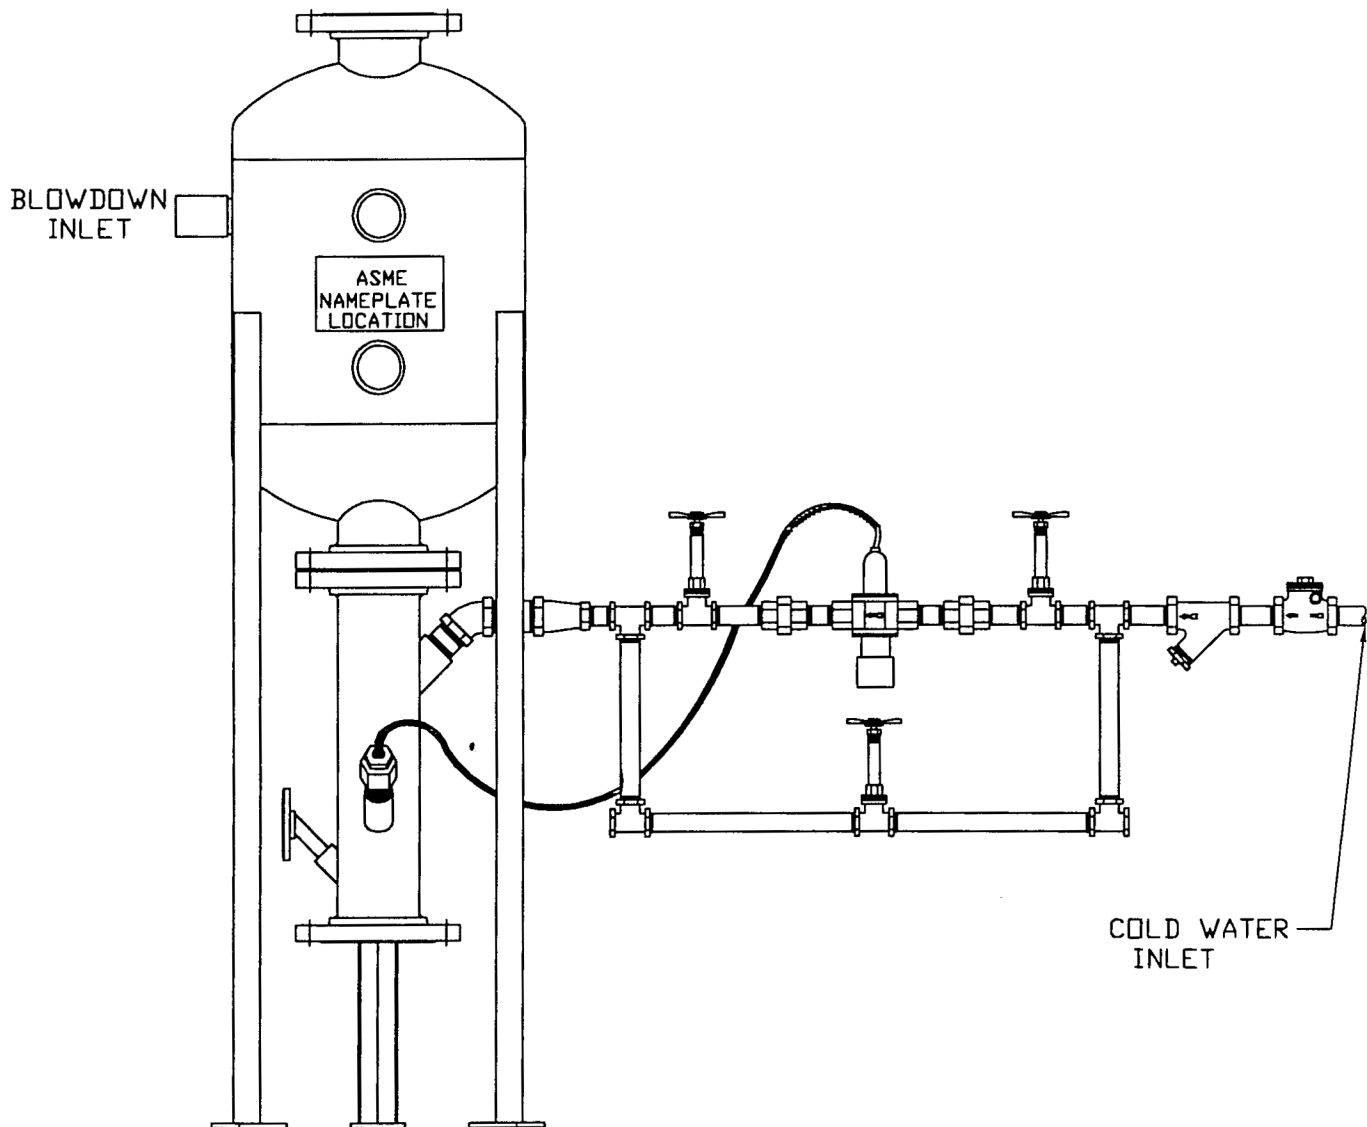

BRYAN STEAM

783 CHILI AVE.

PERU, INDIANA 46970

DWG. TITLE:

TYPICAL INSTALLATION DIAGRAM
FOR A BLOWDOWN SEPARATOR
WITH SUGGESTED PIPING LAYOUT

REVISION NO.

0

EFFECTIVE DATE

10-26-92

SCALE

3/32"=1'

DISK

5-021

FORM NO.

2239