

PACKAGED ROOF TOP UNIT SCHEDULE

TAG	ARRANGEMENT	FAN AND AIRFLOW DATA			COOLING/HEATING DATA		ELEC. CHAR.				DESIGN BASIS		REMARKS	
		AIR VOLUME (CFM)	EXT. SP. (IN. W.C.)	MINIMUM OA (CFM)	COOLING CAP. (MBH)	HEATING INPUT (MBH)	V	PH	HZ	MCA	MOP	MFR.		MODEL
RTU-1	DOWNFLOW	2300	.4	-	75.0	120.0	208	3	60	35	50	TRANE	PRECEDENT	1,3,4
RTU-2	DOWNFLOW	2300	.4	-	75.0	120.0	208	3	60	35	50	TRANE	PRECEDENT	1,3,4
RTU-3	DOWNFLOW	2300	.4	-	75.0	120.0	208	3	60	35	50	TRANE	PRECEDENT	1,3,4
RTU-4	DOWNFLOW	2300	.4	-	75.0	120.0	208	3	60	35	50	TRANE	PRECEDENT	1,3,4

- NOTES:
 1. FURNISH WITH STANDARD 14" CURB.
 2. NOT USED
 3. FURNISH WITH ECONOMIZER
 4. NOT USED
 5. FURNISH WITH BAROMETRIC RELIEF
 6. NOT USED
 7. FURNISH WITH CONVENIENCE OUTLET
 8. FURNISH WITH BUILT IN DISCONNECT

FAN SCHEDULE

TAG	SERVICE LOCATION	AIR VOL. (CFM)	EXT. SP. (IN. W.C.)	FAN SPEED (RPM)	MOTOR HP	DRIVE	FAN TYPE	ELEC. CHAR.			DESIGN BASIS		REMARKS
								V	PH	HZ	MFR.	MODEL	
EF-1-4	RESTROOMS CEILING	75	.1	900	-	DIRECT	CEILING	120	1	60	GREENHECK	SP-890	1


- NOTES:
 1. FURNISH WITH BACKDRAFT DAMPER.

GENERAL NOTES

- ALL DUCTWORK TO BE GALVANIZED AND CONSTRUCTED PER SMACNA LOW PRESSURE STANDARDS.
- ALL OUTSIDE DIMENSIONS ARE SHOWN ON DUCTWORK.
- ALL SUPPLY RECTANGULAR DUCTWORK TO BE CONTAIN 1" DUCT LINER.
- ALL GAS PIPING TO BE SCHEDULE 40 STEEL AND TERMINATED WITH DIRT LEG, UNION AND ISOLATION VALVE.
- ALL THERMOSTATS TO BE 7-DAY PROGRAMMABLE.

KEYED NOTES

- FURNISH AND INSTALL SUPPLY/RETURN DUCT DROPS THRU CURBS. DUCT TO BE EXTENDED BY OTHERS WHEN TENANT FIT-OUT OCCURS.
- EACH TENANT SPACE TO BE METERED INDIVIDUALLY.

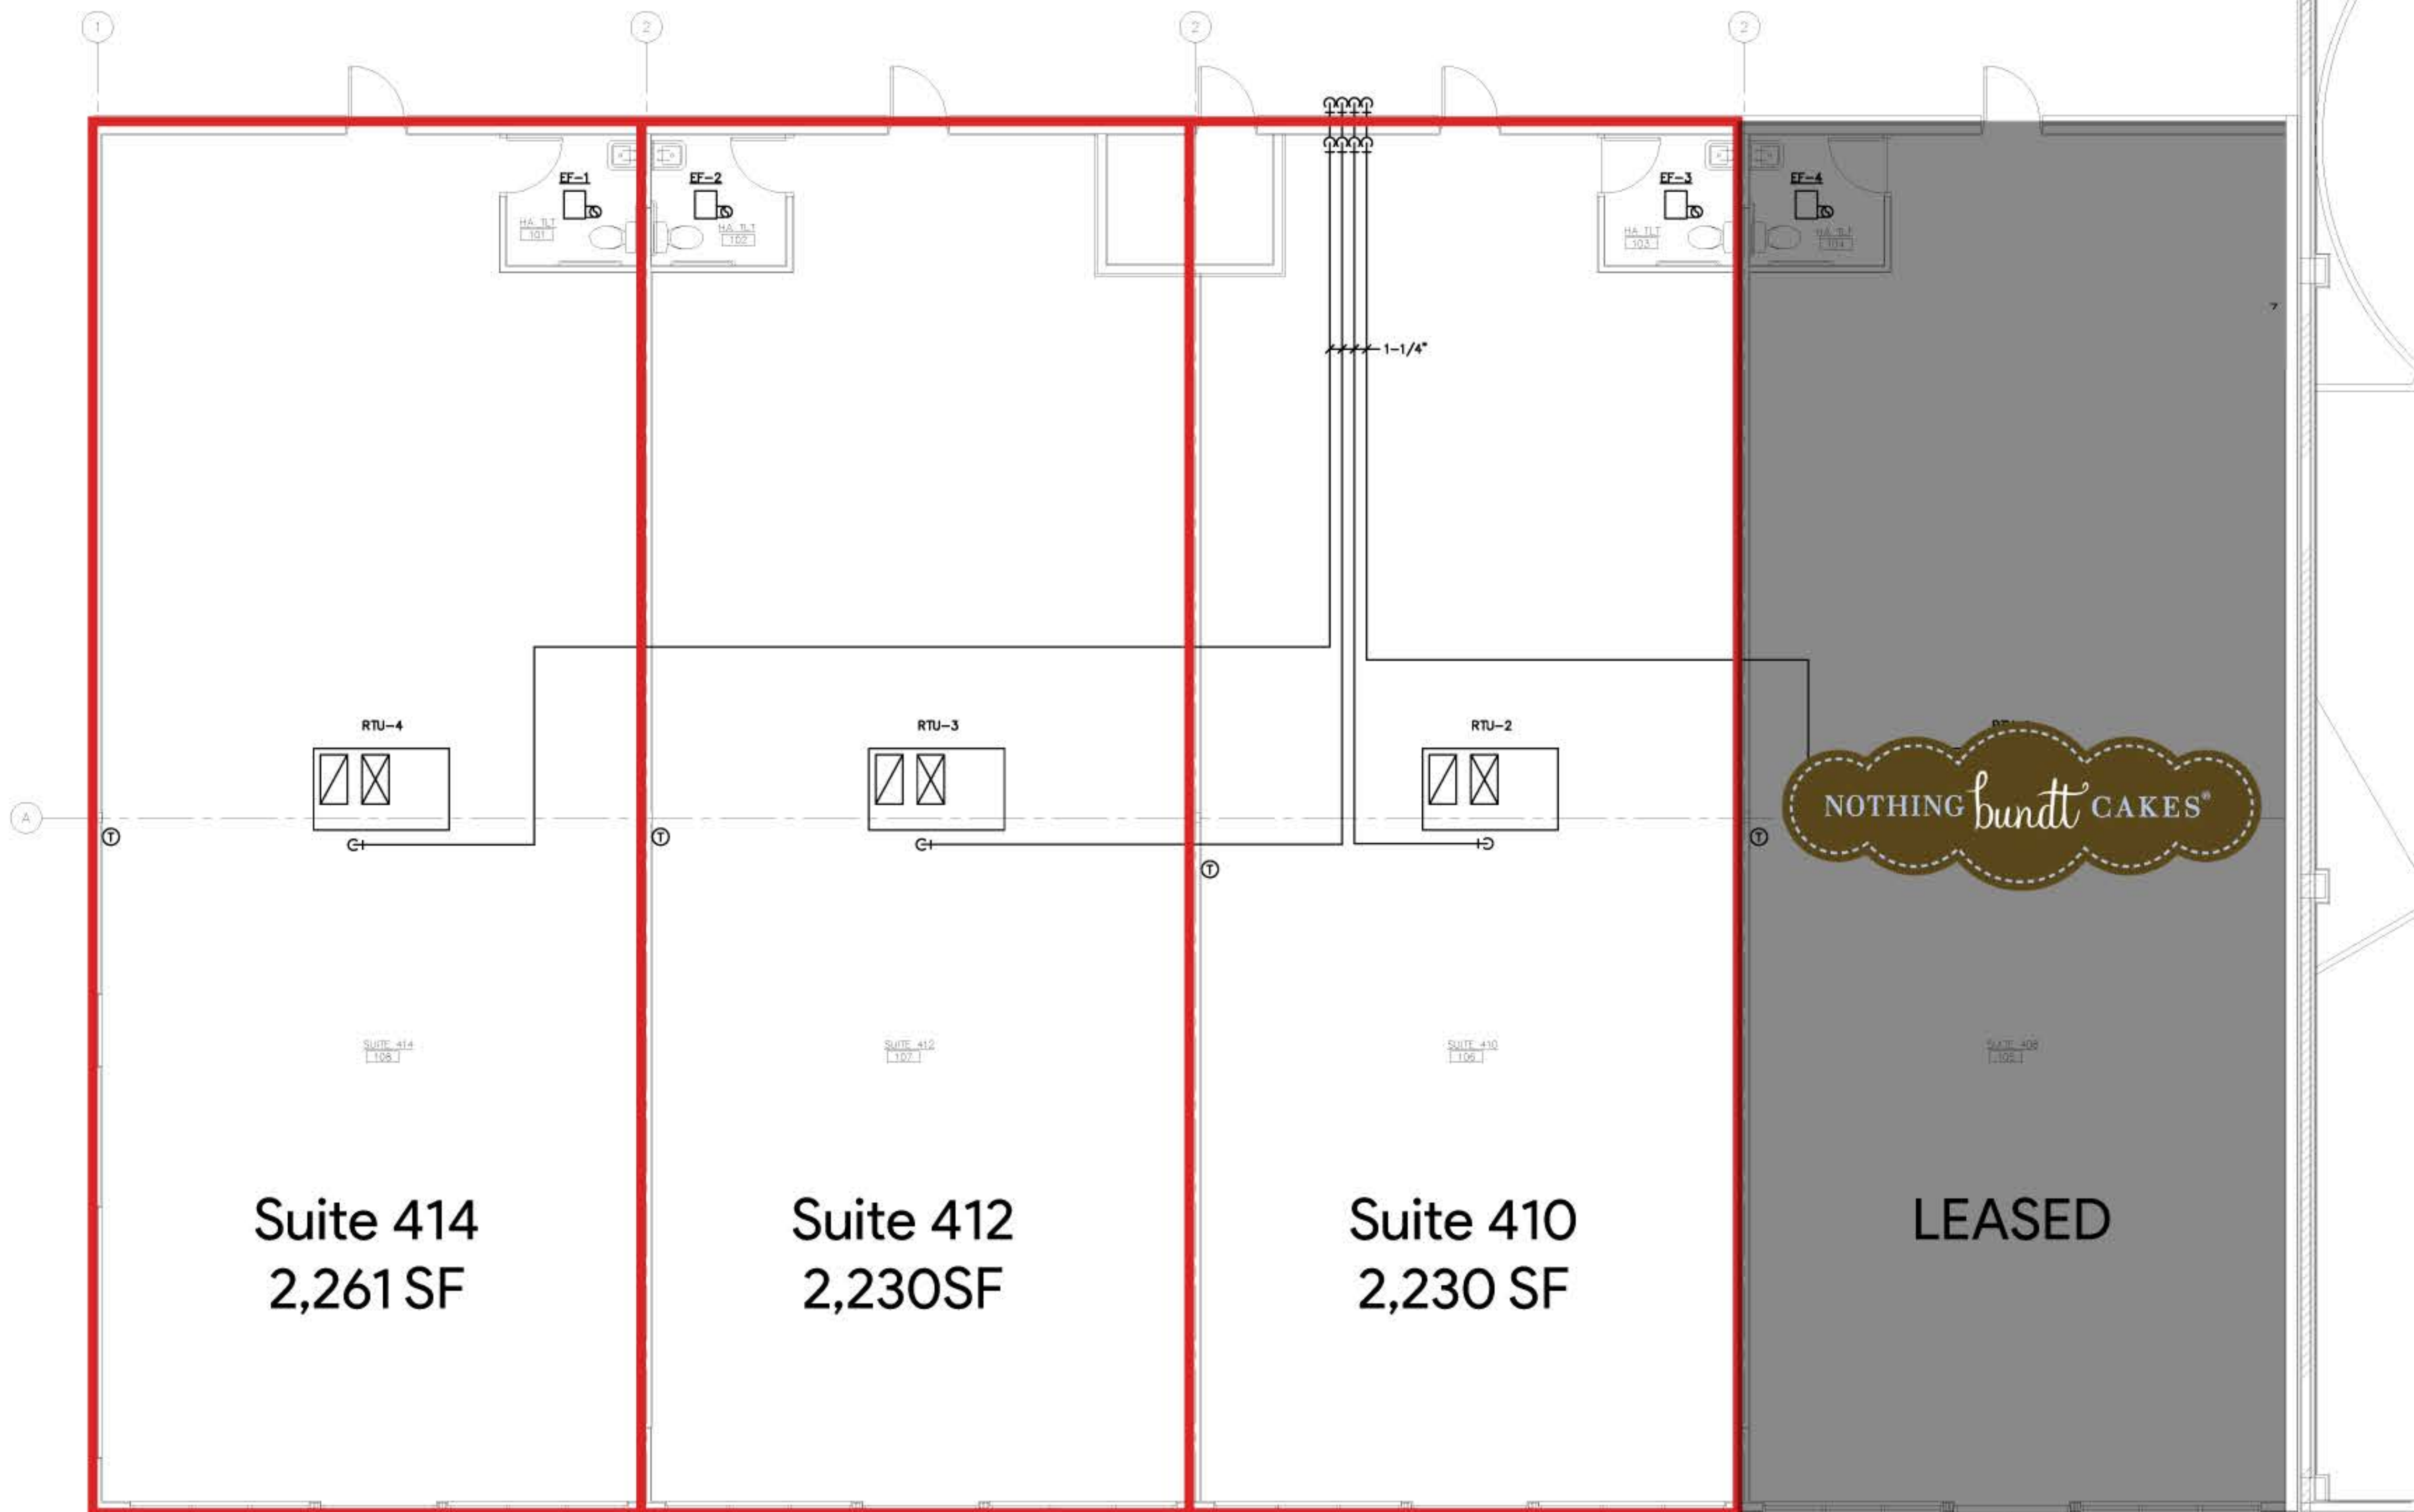

FLOOR PLAN
 SCALE: 3/16"=1'-0"

AUGUST 28, 2019
 DATE

 EXPIRES NOV. 30, 2019
 SIGNATURE

General Notes

Seal Expires 11-30-20

Signature _____ Date _____

No.	Revision/Issue	Date

Client Name and Address
JSM
 Development Services, LLC
 505 S. FIFTH STREET
 CHAMPAIGN, ILLINOIS 61820
 (217) 359-5835 (217) 359-5839 -FAX

Project Name and Address
MARKET PLACE
 CROSSING
 VANILLA BOX
 408-414 W. TOWN CENTER BLVD.
 CHAMPAIGN, IL

Project	Sheet
Date	M1.1
Scale	