




Date Signed: FEB. 8, 2017
Expiration Date: NOV. 30, 2018

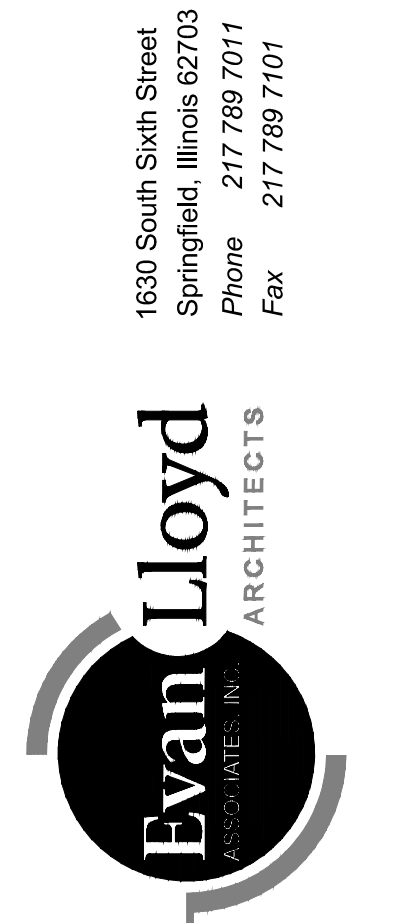

INTERIOR REMODEL
DEPARTMENT OF INNOVATION & TECHNOLOGY
711 WEST JEFFERSON STREET
SPRINGFIELD, ILLINOIS

Date: FEB. 8, 2017
Project No. IS-082c
Drawn By: BCH / BRH
Revised: MAR. 21, 2017
Revised:

SHEET
A-1
OF 20 SHEETS

SYMBOL LEGEND



- ROOM NAME AND NUMBER
- DOOR NUMBER
- INTERIOR ELEVATION DESIGNATION
- WALL TYPES
- BUILDING SECTION TAG
- PARTIAL SECTION TAG
- DETAIL CALLOUT
- SEMI-RECESSED WALL MOUNTED FIRE EXTINGUISHER CABINET (5 LB. EXTINGUISHER U.N.O.)

GENERAL CONSTRUCTION NOTES:

- NEW INTERIOR WALL DIMENSIONS ARE FROM FACE OF METAL STUDS. DIMENSIONS FROM EXISTING WALLS ARE FROM FACE OF FINISHED WALL.
- PATCH AND REPAIR EXISTING WALLS, FLOORS AND CEILINGS AT ALL NEW CONSTRUCTION AND THROUGHOUT BUILDING AS NEEDED.
- BUILDING MATERIALS SHALL HAVE A FLAME SPREAD RATING OF 25 OR LESS, AND A SMOKE DEVELOPED RATING OF 50 OR LESS WHEN TESTED IN ACCORDANCE WITH A.S.T.M. E-84.
- ALL COUNTERTOP OUTSIDE CORNERS TO HAVE A 1" RADIUS UNLESS NOTED OTHERWISE.
- ALL SHELVING, TABLES, CHAIRS AND APPLIANCES TO BE PROVIDED BY THE TENANT UNLESS NOTED OTHERWISE.
- GENERAL CONTRACTOR TO PROVIDE WOOD BLOCKING FOR SHELVING, PLUMBING FIXTURES AND ACCESSORIES, AND CASEWORK AS NEEDED. COORDINATE WORK WITH ALL TRADES.
- COORDINATE WORK WITH HARBOR FREIGHT.
- PATCH AND REPAIR ALL SURFACES ADJACENT TO THE REMOVAL WORK WHICH IS TO REMAIN.

1 FRAMING DETAIL

SCALE: 1/2" = 1'-0"

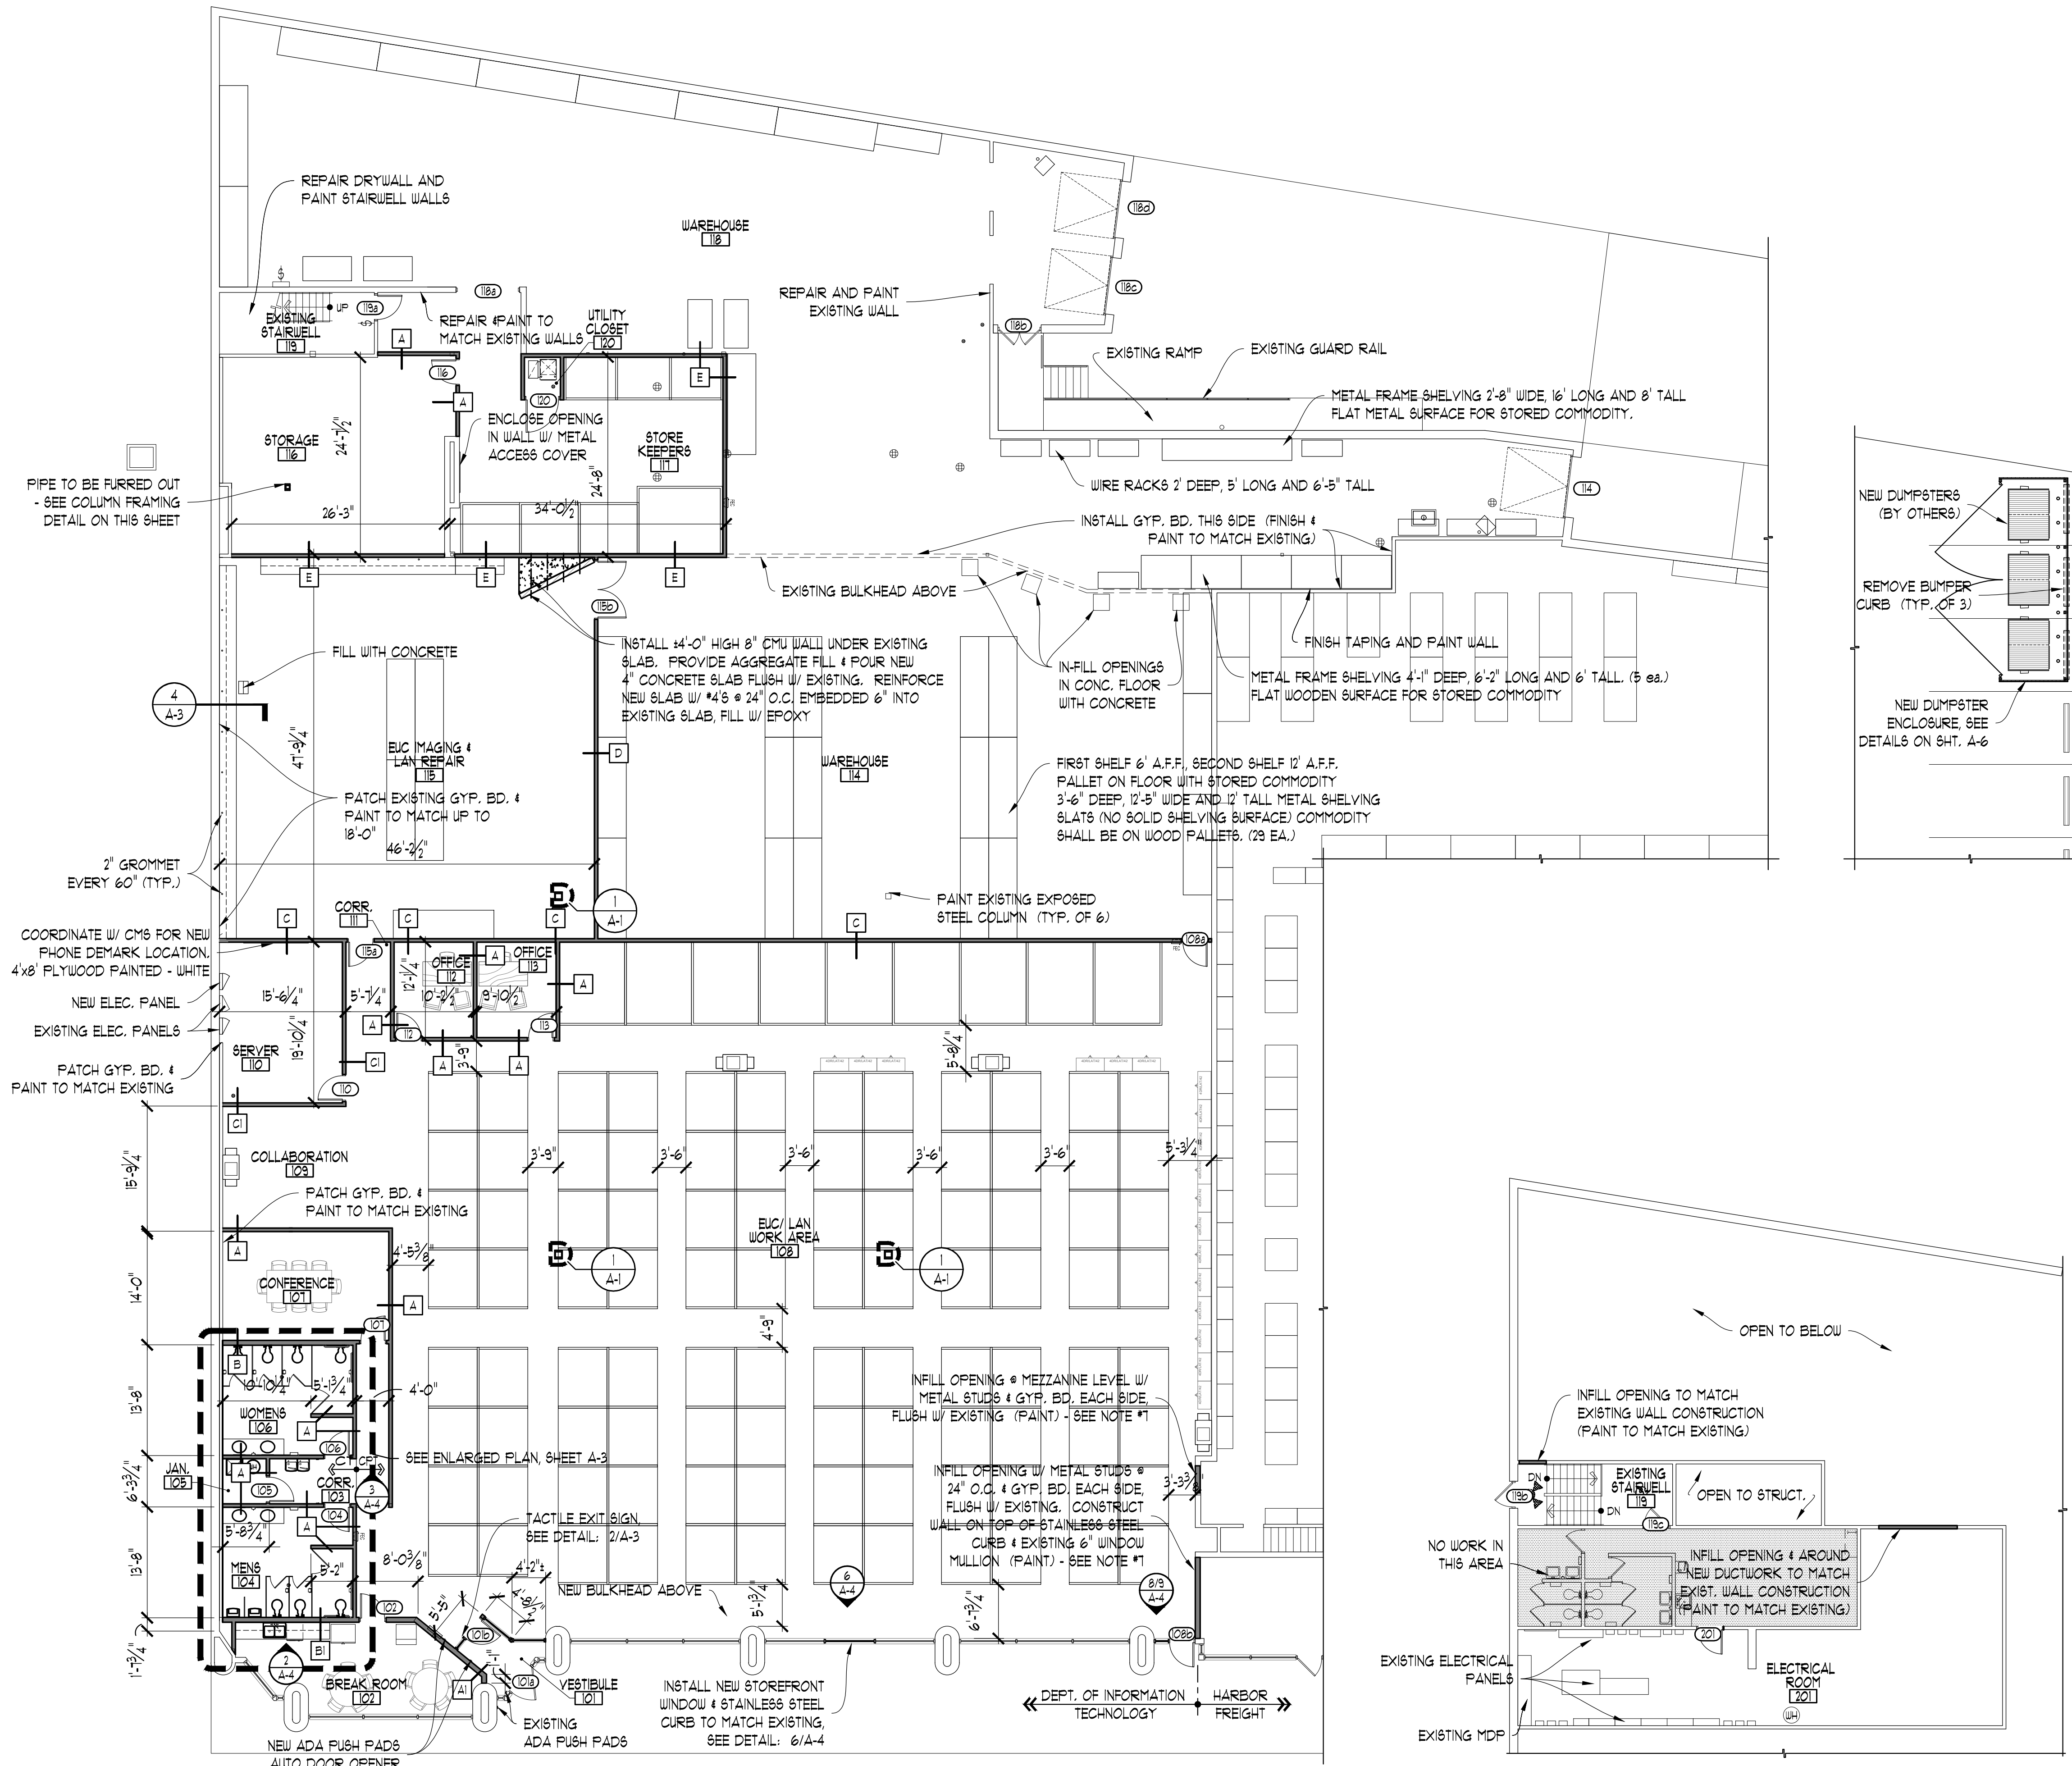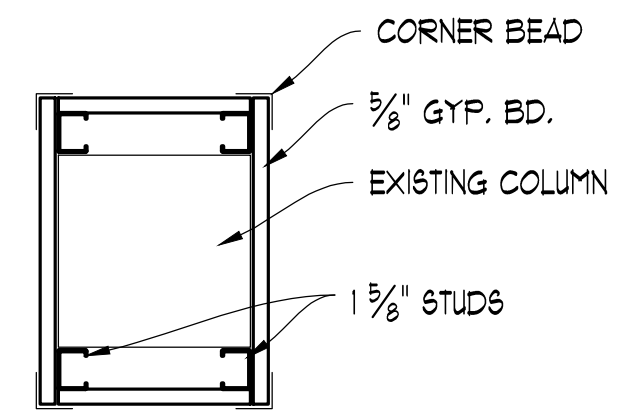

NEW FLOOR PLAN

SCALE: 3/32" = 1'-0"

EXISTING MEZZANINE FLOOR PLAN

SCALE: 3/32" = 1'-0"