



ABBREVIATIONS

a	CIRCUIT BREAKER AUX. CONTACT, CLOSED WHEN BREAKER IS CLOSED	GEN	GENERATOR	P	POLE, PUMP
A	AMMETER, AMPERES	GFI	GROUND FAULT INTERRUPTER	PB	PULLBOX
AC	ALTERNATING CURRENT	GND	GROUND	PBSW	PUSHBUTTON SWITCH
A/D	ANALOG TO DIGITAL	GRS	GALVANIZED RIGID STEEL	PC	PHOTO CELL
ADJ	ADJUSTABLE	O ₂ H ₂	HYDROGEN PEROXIDE	PEC	PHOTOELECTRIC CELL
AF	AMPERE FRAME	HH	HANDHOLE	PF	POWER FACTOR
AFD	ADJUSTABLE FREQUENCY DRIVE	HOA	HAND-OFF-AUTOMATIC	PG	
AIC	AMPERES INTERRUPTING CAPACITY	HOR	HAND-OFF-REMOTE	pH	MEASURE OF ACIDITY OR ALKALINITY
AMP	AMPERES	HPS	HIGH PRESSURE SODIUM	PH	PHASE
ANN	ANNUNCIATOR	HT	HEAT TAPE, HEAT TRACE	PIOP	PLC I/O PANEL
API		HTR	HEATER	PLC	PROGRAMMABLE LOGIC CONTROLLER
AS	AMMETER SWITCH	HV	HIGH VOLTAGE	PNL	PANEL
AT	AMPERE TRIP	HZ	HERTZ (CYCLES PER SECOND)	PNLBD	PANELBOARD
ATS	AUTOMATIC TRANSFER SWITCH	IND LT	INDICATING LIGHT	POSN	POSITION
AUTO	AUTOMATIC	INCAND	INCANDESCENT	POT	POTENTIOMETER
AWG	AMERICAN WIRE GAGE	INSTR	INSTRUMENT, INSTRUMENTATION	PPS	PACKAGED POWER SUPPLY
b	CIRCUIT BREAKER AUX. CONTACT, CLOSED WHEN BREAKER IS OPEN	I/O	INPUT/OUTPUT	PRI	PRIMARY
BCG	BARE COPPER GROUND	ISB	INTRINSICALLY SAFE BARRIER	PSH	PRESSURE SWITCH HIGH POWER
C	CONDUIT	ISR	INTRINSICALLY SAFE RELAY	PWR	(R) RELOCATED
CAB	CABINET	JB	JUNCTION BOX	RCPT	RECEPTACLE
CAP	CAPACITOR	KA	KILOAMPERES	RCT	REPEAT CYCLE TIMER
CB	CIRCUIT BREAKER	KCMIL	THOUSANDS OF CIRCULAR MILS	REF	REFERENCE
CC	CONTROL CABLE, CLOSING COIL	KV	KILOVOLTS	RT	RESET TIMER
CHH	COMMUNICATION HANDHOLE	KVA	KILOVOLT AMPERES	SCCR	SHORT CIRCUIT
CC	CLARIFIER CONSOLE	KVAR	KILOVOLT AMPERES		CURRENT RATING
CKT	CIRCUIT	KVARH	KILOVOLT AMPERES REACTIVE HOURS	SCR	SILICON CONTROLLED RECTIFIER
CMH	COMMUNICATION MANHOLE	LCS	LOCAL CONTROL STATION	SD	SMOKE DETECTOR
CO	CONDUIT ONLY	LSH	LIGHTING	SIG	SIGNAL
COMM	COMMUNICATION	LTS	LIGHTS	SN	SOLID NEUTRAL
COND	CONDUCTOR	LP	LIGHTING PANEL	SPD	SURGE PROTECTION DEVICE
CPT	CONTROL POWER TRANSFORMER	LR	LINE REACTOR	SPDT	SINGLE POLE, DOUBLE THROW
CP	CONTROL PANEL	(M)	MODIFIED	SPST	SINGLE POLE, SINGLE THROW
CR	CONTROL RELAY	mA	MILLIAMPERES	SST	STAINLESS STEEL
CS	CONTROL STATION	MCC	MOTOR CONTROL CENTER	SV	SOLENOID VALVE
CT	CURRENT TRANSFORMER	MCP	MOTOR CIRCUIT PROTECTION OR MAIN CONTROL PANEL	SW	SWITCH
DB	DIRECT BURIAL	MCM	THOUSAND CIRCULAR MILS (KCMIL)	SWBD	SWITCHBOARD
DC	DIRECT CURRENT	MFR	MANUFACTURER	SWGR	SWITCHGEAR
DIAG	DIAGRAM	MLO	MAIN LUGS ONLY	SYNC	SYNCHRONIZING
DISC	DISCONNECT	MON	MONITOR	TB	TERMINAL BLOCK
DISTR	DISTRIBUTION	MOV	MOTOR OPERATED VALVE	TC	TELEPHONE CABINET
DIV	DIVISION	MS	MOTOR STARTER	TEL	TELEPHONE
DP	DISTRIBUTION PANEL	MTD	MOUNTED	TER	TERMINAL
DPDT	DOUBLE POLE, DOUBLE THROW	MTG	MOUNTING	TO	TIMED OPENING
DPST	DOUBLE POLE, SINGLE THROW	MTS	MANUAL TRANSFER SWITCH	TOA	TEST-OFF-AUTOMATIC
(E)	EXISTING	MV	MEDIUM VOLTAGE	TSP	TWISTED SHIELDED PAIR
EE	ELECTRICAL ENCLOSURE	(N)	NEW	TST	TWISTED SHIELDED TRIAD
EHH	ELECTRICAL HANDHOLE	NC	NORMALLY CLOSED	TVSS	TRANSIENT VOLTAGE SURGE SUPPRESSOR
ELEM	ELEMENTARY	NECA	NATIONAL ELECTRICAL MANUFACTURER'S ASSOC.	UGND	UNDERGROUND
EMERG	EMERGENCY	NEMA	NATIONAL ELECTRICAL MANUFACTURER'S ASSOC.	UPS	UNINTERRUPTIBLE POWER SUPPLY
ENCL	ENCLOSURE	NEUT	NEUTRAL	VA	VOLT-AMPERES
EFFL	EFFLUENT	NO	NORMALLY OPEN, NUMBER	VAR	VOLT AMPERES
EGC	EQUIPMENT GROUND CONDUCTOR	OC	ON CENTER	VFD	REACTIVE VARIABLE FREQUENCY DRIVE
EMT	ELECTRICAL METALLIC TUBING	OCP	OZONE CONTROL PANEL	VH	VAR-HOUR
EQPT	EQUIPMENT	OL	OVERLOAD	VS	VOLTMETER SWITCH
ETM	ELAPSED TIME METER	OT	OVER TEMPERATURE	W	WIRE, WATTS
FCV	FLOW CONTROL VALVE	OVLD	THERMAL OVERLOAD RELAY	WH	WATTHOUR METER
FDR	FEEDER	OIT	OPERATOR INTERFACE TERMINAL	WHDM	WATTHOUR DEMAND METER
FE	FLOW ELEMENT			WP	WEATHERPROOF
FIT	FLOW INDICATING TRANSMITTER			WR	WEATHER RESISTANT
FLEX	FLEXIBLE			WT	WATERTIGHT
FLUOR	FLUORESCENT			WWR	WASHWATER RECOVERY
FREQ	FREQUENCY			XFMR	TRANSFORMER
FSH	FLOAT SWITCH HIGH				
FSO	FLOAT SWITCH OVERFLOW				
FU	FUSE				
(F)	FUTURE FUT, FULL VOLTAGE, NON REVERSING				
FVR	FULL VOLTAGE, REVERSING				
FWD	FORWARD				

PLAN SYMBOLS

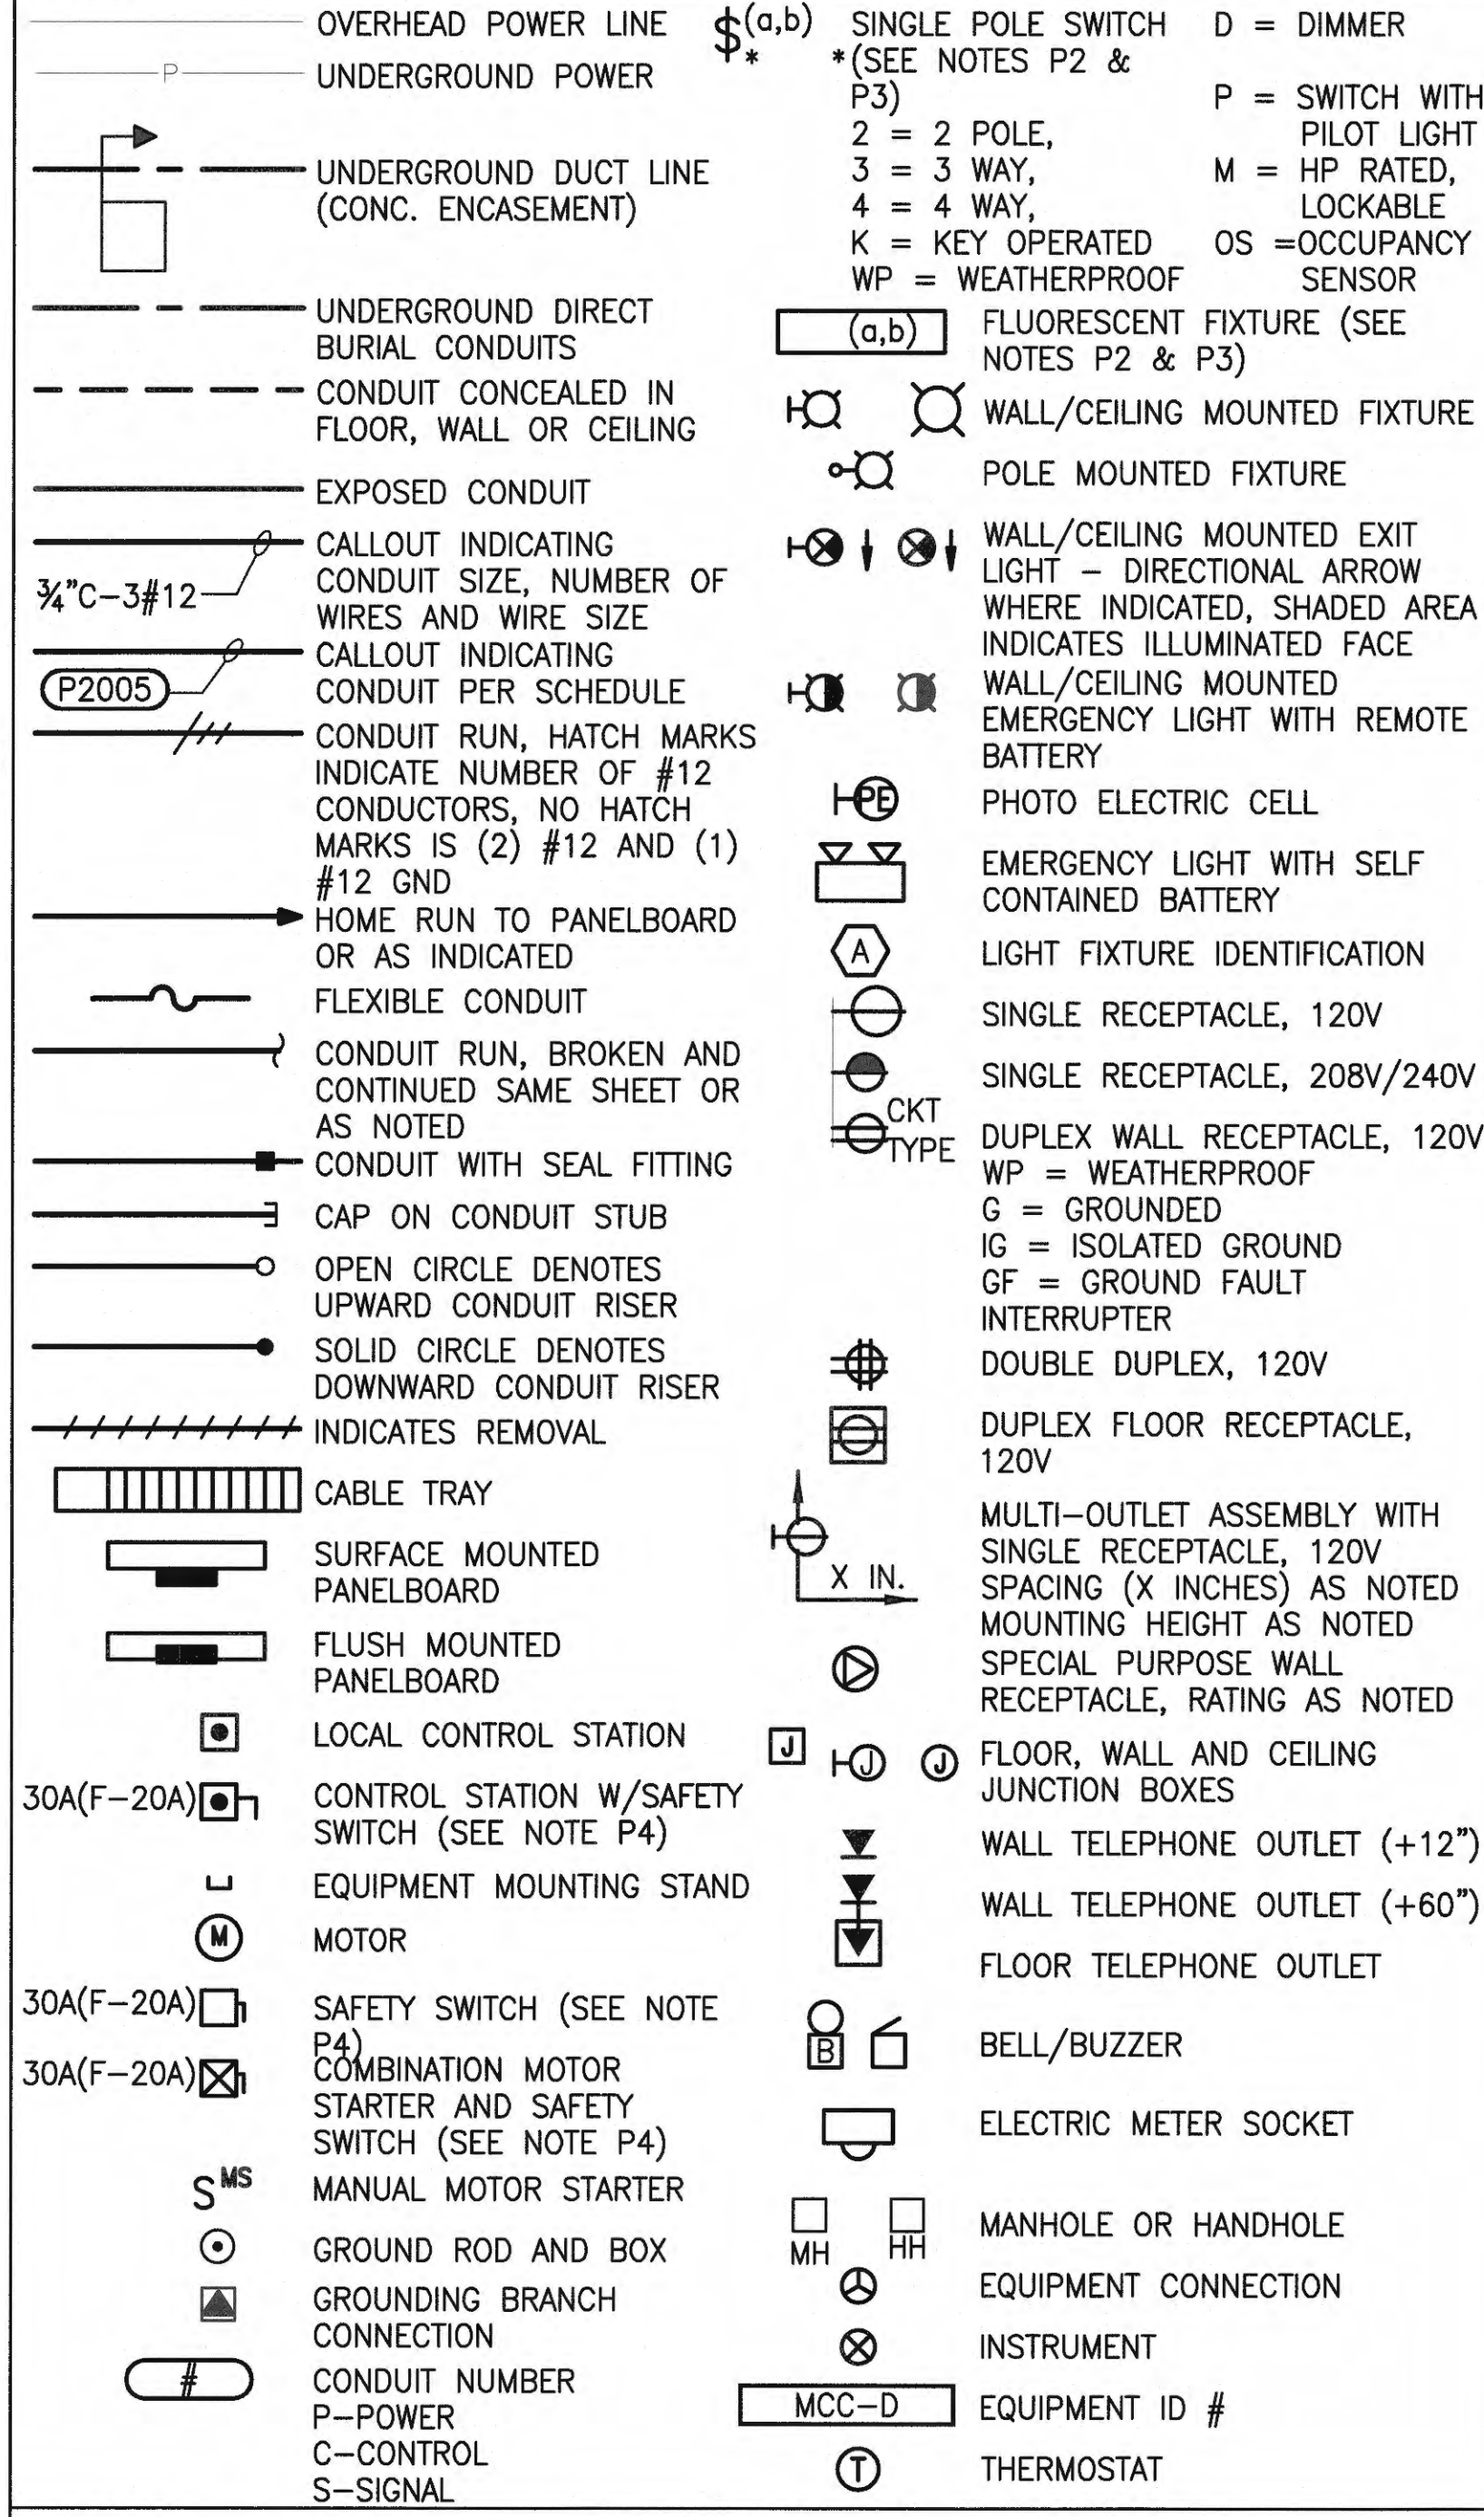


FIRE ALARM

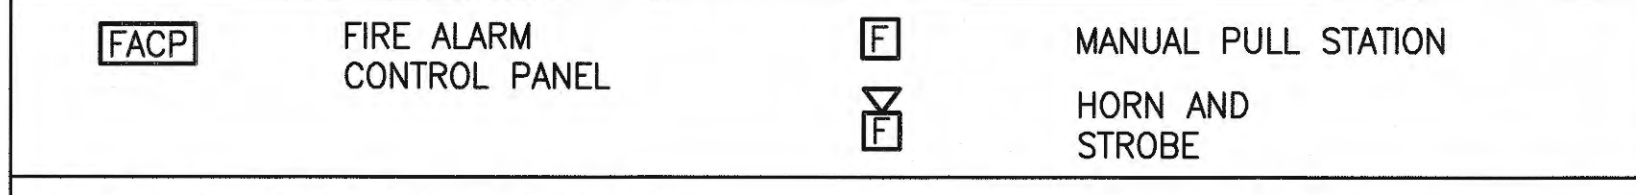


PLAN SYMBOL NOTES

- P1 CONDUIT SIZE AND FILL SHALL BE AS INDICATED. WHERE NO SIZE IS SHOWN, THE CONDUIT SHALL BE SIZED IN ACCORDANCE WITH THE EDITION OF THE NATIONAL ELECTRICAL CODE ADOPTED BY THE AUTHORITY HAVING CODE ENFORCEMENT. JURISDICTION. WHERE NO FILL IS INDICATED, PROVIDE (3) #12 WIRES. PROVIDE 3/16 INCH NYLON PULL ROPE IN EACH EMPTY CONDUIT.
- P2 LOWER CASE LETTERS IN PARENTHESIS ADJACENT TO A SWITCH OR LIGHT FIXTURE INDICATE A SWITCHED CIRCUIT AND IDENTIFY THE FIXTURE/SWITCH COMBINATIONS. FOR FOUR LAMP FLUORESCENT FIXTURES WIRED IN PAIRS WITHIN EACH FIXTURE, THE "a" SWITCH CONTROLS THE OUTER LAMPS AND THE "b" SWITCH CONTROLS THE INNER LAMPS. WIRE 3 LAMP FIXTURES SIMILARLY.
- P3 NUMBERS IN PARENTHESIS ADJACENT TO A LIGHT FIXTURE OR RECEPTACLE INDICATE THE LIGHTING PANEL BRANCH CIRCUIT FEEDING THE DEVICE.
- P4 NUMBER INDICATES THE AMPERAGE RATING OF THE SWITCH. IDENTIFIERS IN PARENTHESIS INDICATE THAT THE SWITCH IS PROVIDED WITH FUSES AND THE AMPERAGE RATING OF THE FUSE(S).

SINGLE LINE SYMBOLS

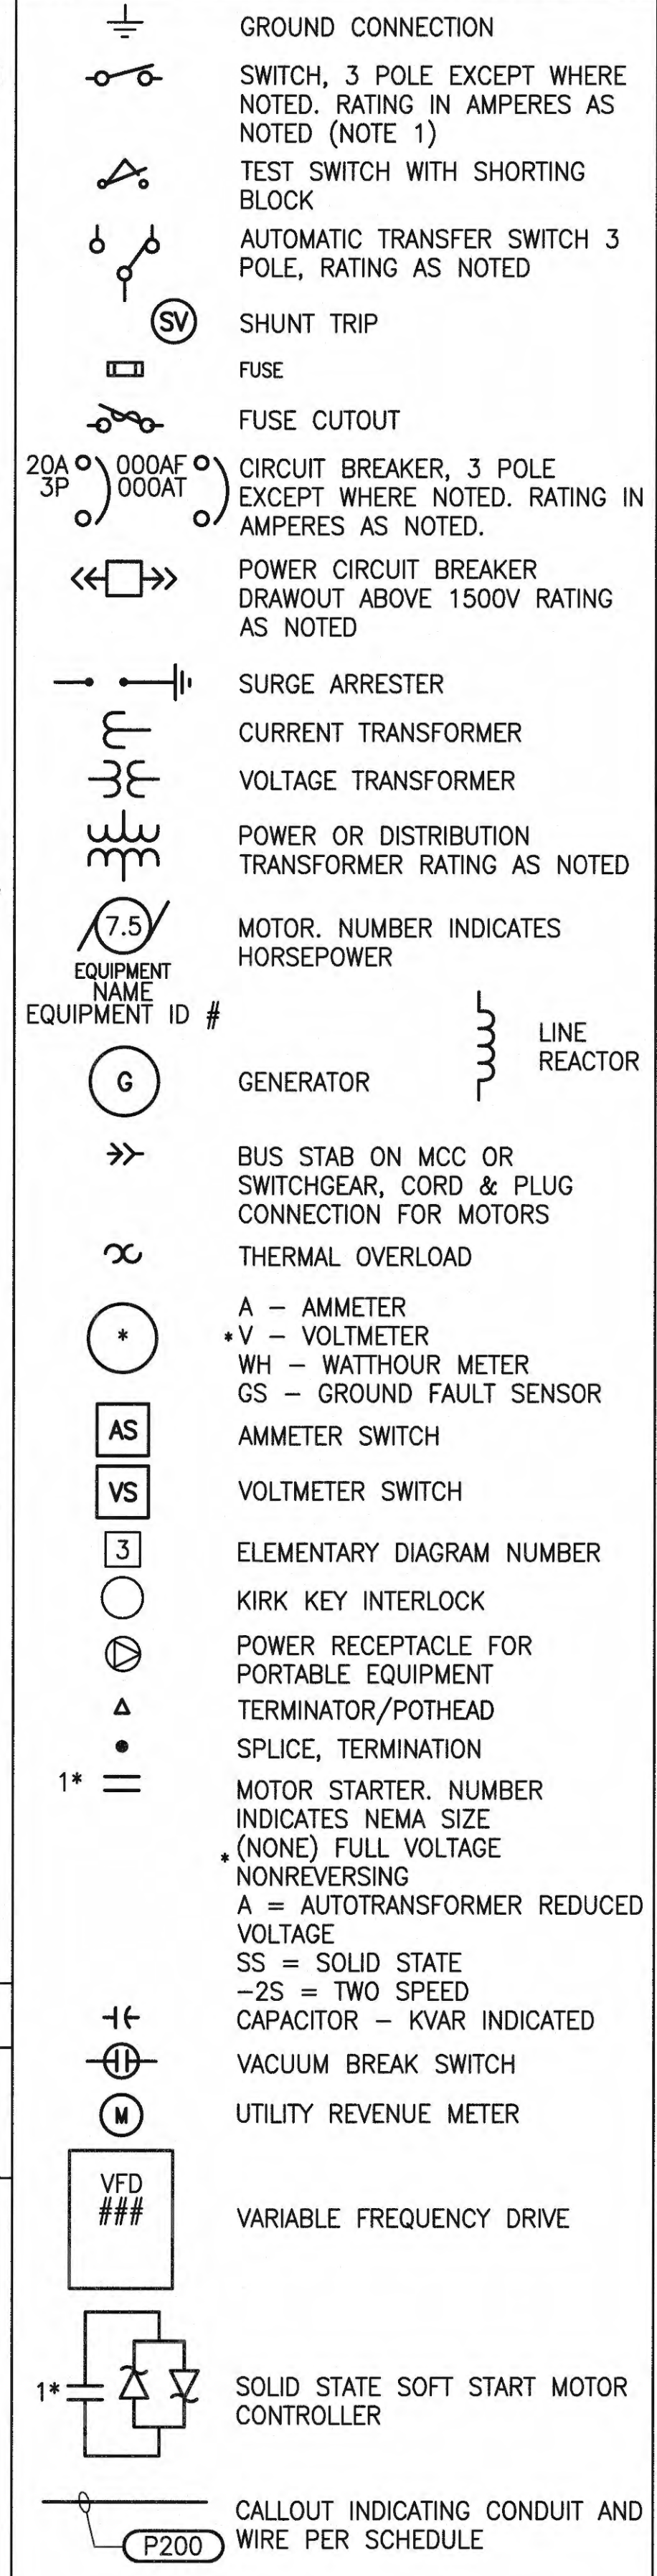

LOOP WIRING/ELEMENTARY DIAGRAM SYMBOLS

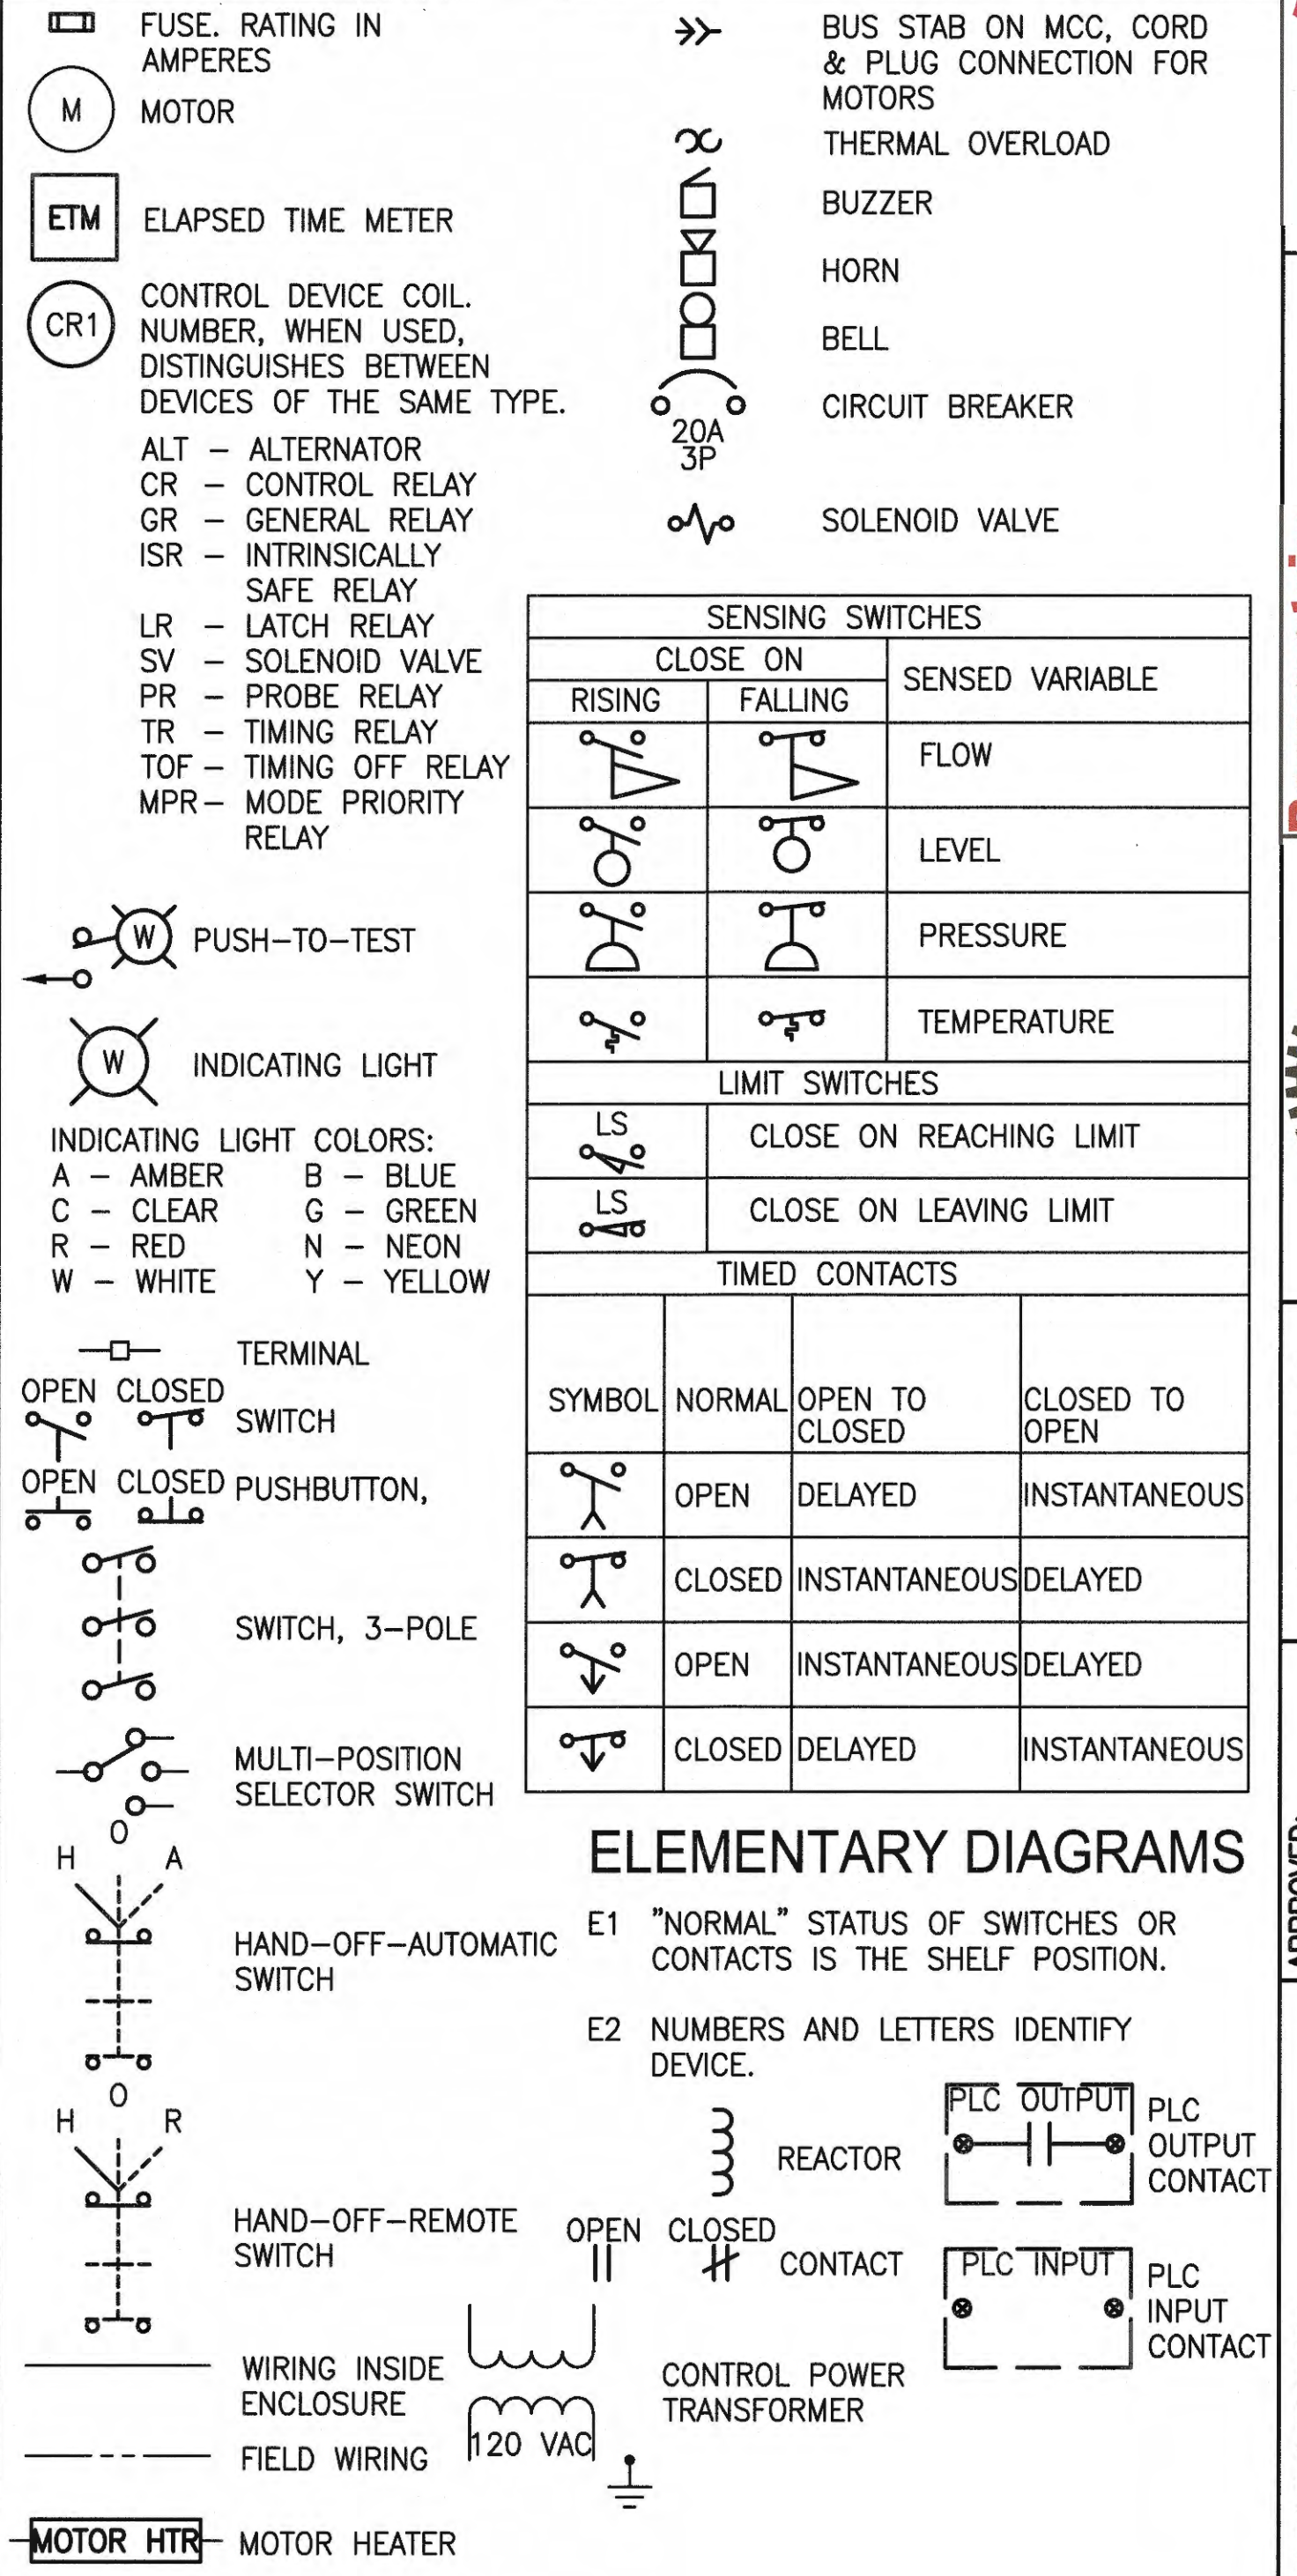

GENERAL NOTES

- G1 THE INSTALLATION OF ALL EQUIPMENT SHOWN ON THESE DRAWINGS OR DESCRIBED IN THE SPECIFICATIONS SHALL CONFORM TO THE REQUIREMENTS SET FORTH IN THE LATEST EDITIONS OF ALL APPLICABLE CODES AND UTILITY COMPANY STANDARDS. CONTACT THE UTILITY COMPANY REPRESENTATIVES AND VERIFY THEIR REQUIREMENTS.
- G2 THIS IS A GENERALIZED LEGEND SHEET. THIS CONTRACT MAY NOT USE ALL INFORMATION SHOWN.
- G3 NOTIFY THE ENGINEER IMMEDIATELY IF CONFLICTS IN EQUIPMENT LOCATIONS ARE DISCOVERED OR IF PROBLEMS ARISE DUE TO FIELD CONDITIONS, LACK OF INFORMATION OR ANY OTHER REASON.
- G4 INFORMATION SHOWN MAY NOT BE ALL INCLUSIVE. SEE ALSO ANSI C37.2, Y1.1, Y32.2, AND Y32.9.
- G5 REFER TO THE MECHANICAL DRAWINGS FOR EXACT LOCATIONS OF MECHANICAL EQUIPMENT AND FOR CERTAIN CONNECTIONS TO BE MADE TO ELECTRICAL CIRCUITS.
- G6 EQUIPMENT SHOWN IN 1/2 TONE OR GREY TONE ARE EXISTING OR BY OTHERS.
- G7 VERIFY ALL COLOR REQUIREMENTS BEFORE ORDERING MATERIALS.

Port of Tacoma
P.O. BOX 1887 TACOMA, WA 98401 (206)383-9441

Parametrix
ENGINEERING - PLANNING - ENVIRONMENTAL SCIENCES
80 WASHINGTON AVENUE, SUITE 390
SEASIDE, WA 98372
WWW.PARAMETRIX.COM

SEAL OF THE PORT OF TACOMA
ESTABLISHED 1890
TACOMA, WA


APPROVED: *[Signature]*
DIRECTOR
4/26/18
DATE: APR 25, 2018

AGS MAR 2018
CHECKED BY: JEM
DATE: APR 2018
PROJ. ENGR. DATE: Apr 25, 2018
PRINTED BY: peterden
PORT ADDRESS: ONE SITCUM PLAZA
TACOMA, WA 98401-1837

WEST SITCUM
STORMWATER TREATMENT
ELECTRICAL LEGEND AND ABBREVIATIONS


6583
E01
SH 38 OF 47
CONTR/CONS: 070664
M. ID: 201024.01
PHASE: BID SET

RANGE: 3E
TOWNSHIP: 21N
SECTION: 33 & 34
DATE-HRZ: WA83-S
PARCEL: SEE G02
DRAWING SCALE: AS NOTED

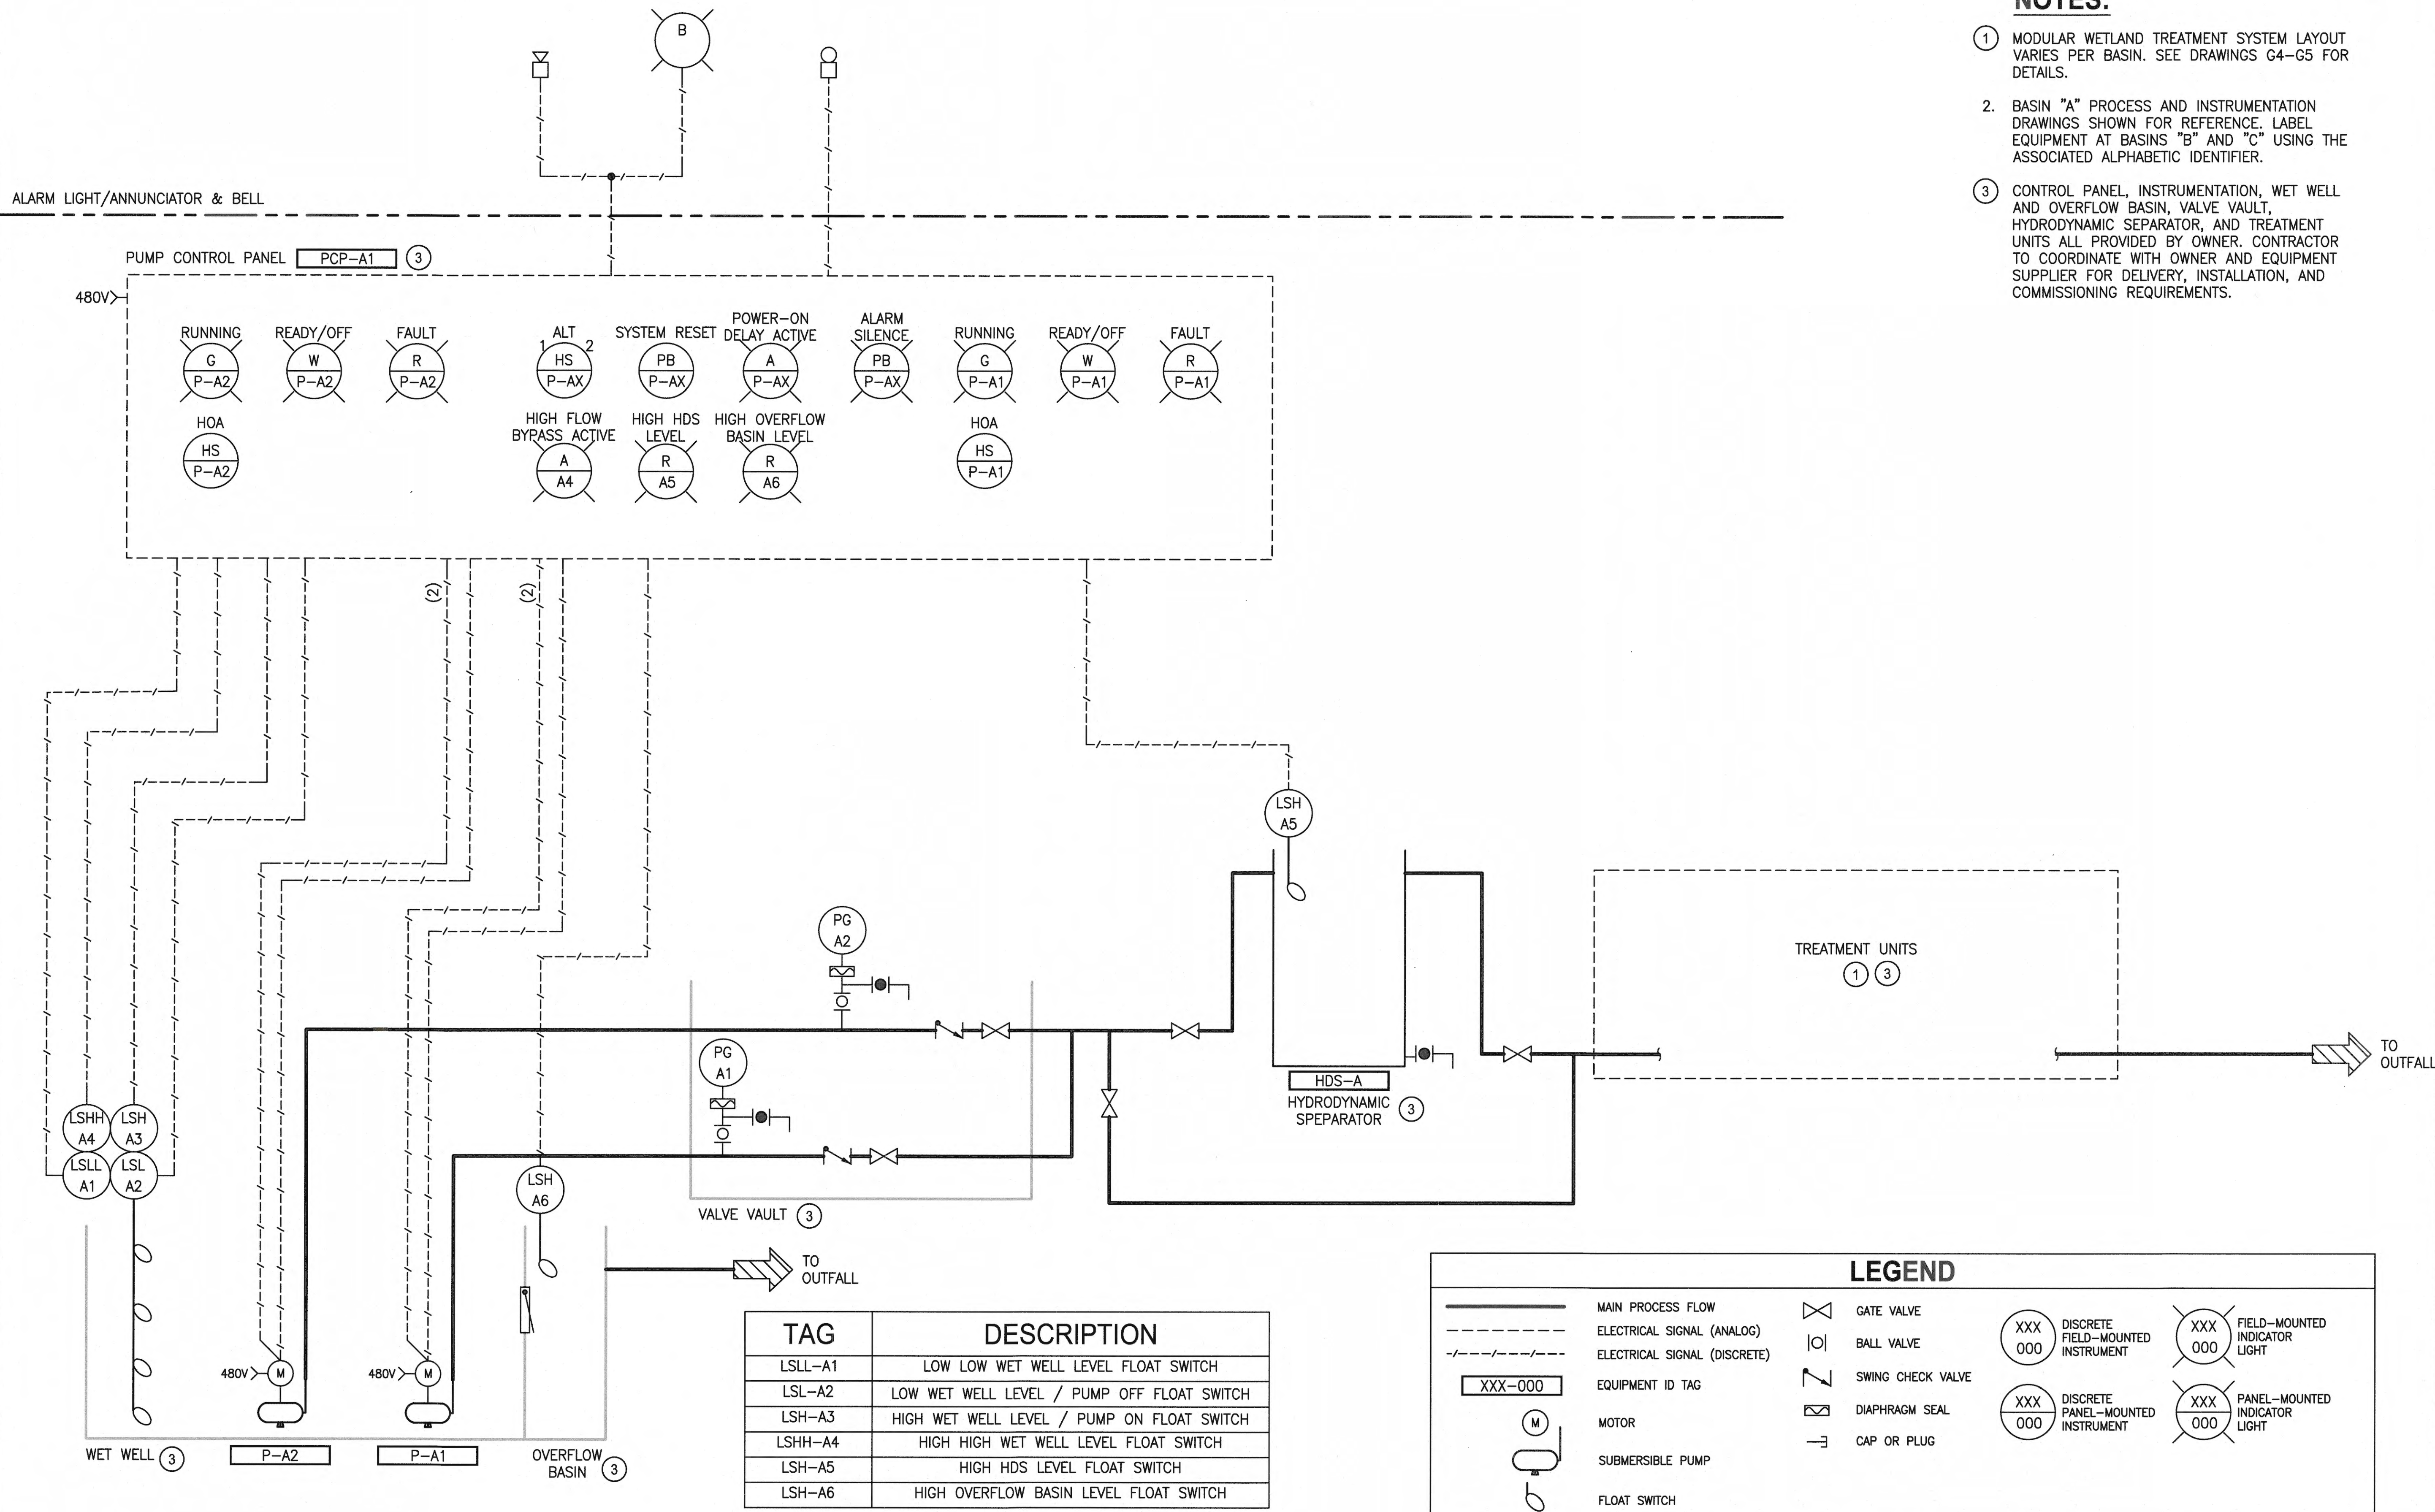

- ① MODULAR WETLAND TREATMENT SYSTEM LAYOUT VARIES PER BASIN. SEE DRAWINGS G4-G5 FOR DETAILS.
2. BASIN "A" PROCESS AND INSTRUMENTATION DRAWINGS SHOWN FOR REFERENCE. LABEL EQUIPMENT AT BASINS "B" AND "C" USING THE ASSOCIATED ALPHABETIC IDENTIFIER.
- ③ CONTROL PANEL, INSTRUMENTATION, WET WELL AND OVERFLOW BASIN, VALVE VAULT, HYDRODYNAMIC SEPARATOR, AND TREATMENT UNITS ALL PROVIDED BY OWNER. CONTRACTOR TO COORDINATE WITH OWNER AND EQUIPMENT SUPPLIER FOR DELIVERY, INSTALLATION, AND COMMISSIONING REQUIREMENTS.

6583 E03 SH 40 OF 47	WEST SITCUM STORMWATER TREATMENT PIPING & INSTRUMENTATION DIAGRAM - BASIN A		APPROVED: <i>Jane Christensen</i> <u>4/26/18</u>	AGS MAR 2018 CHECKED BY <u>DATE</u> JEM APR 2018		Parametrix ENGINEERING · PLANNING · ENVIRONMENTAL SCIENCES 60 WASHINGTON AVENUE, SUITE 390 BREWERTON, WA 98337 P 360.377.0014 WWW.PARAMETRIX.COM	
	TOWNSHIP: 21N DAT-HRZ: WA83-S PARCEL: SEE G02	RANGE: 3E VERT: MLLW DRAWING SCALE: AS NOTED	DIRECTOR ENG. DATE PROJ. ENGR DATE PRINTED BY: peterden Apr 25, 2018 PORT ADDRESS: ONE SITCUM PLAZA TACOMA, WA 98401-1837	MARK: _____ REVISION: _____ BY: _____ APPR: _____ DATE: _____			

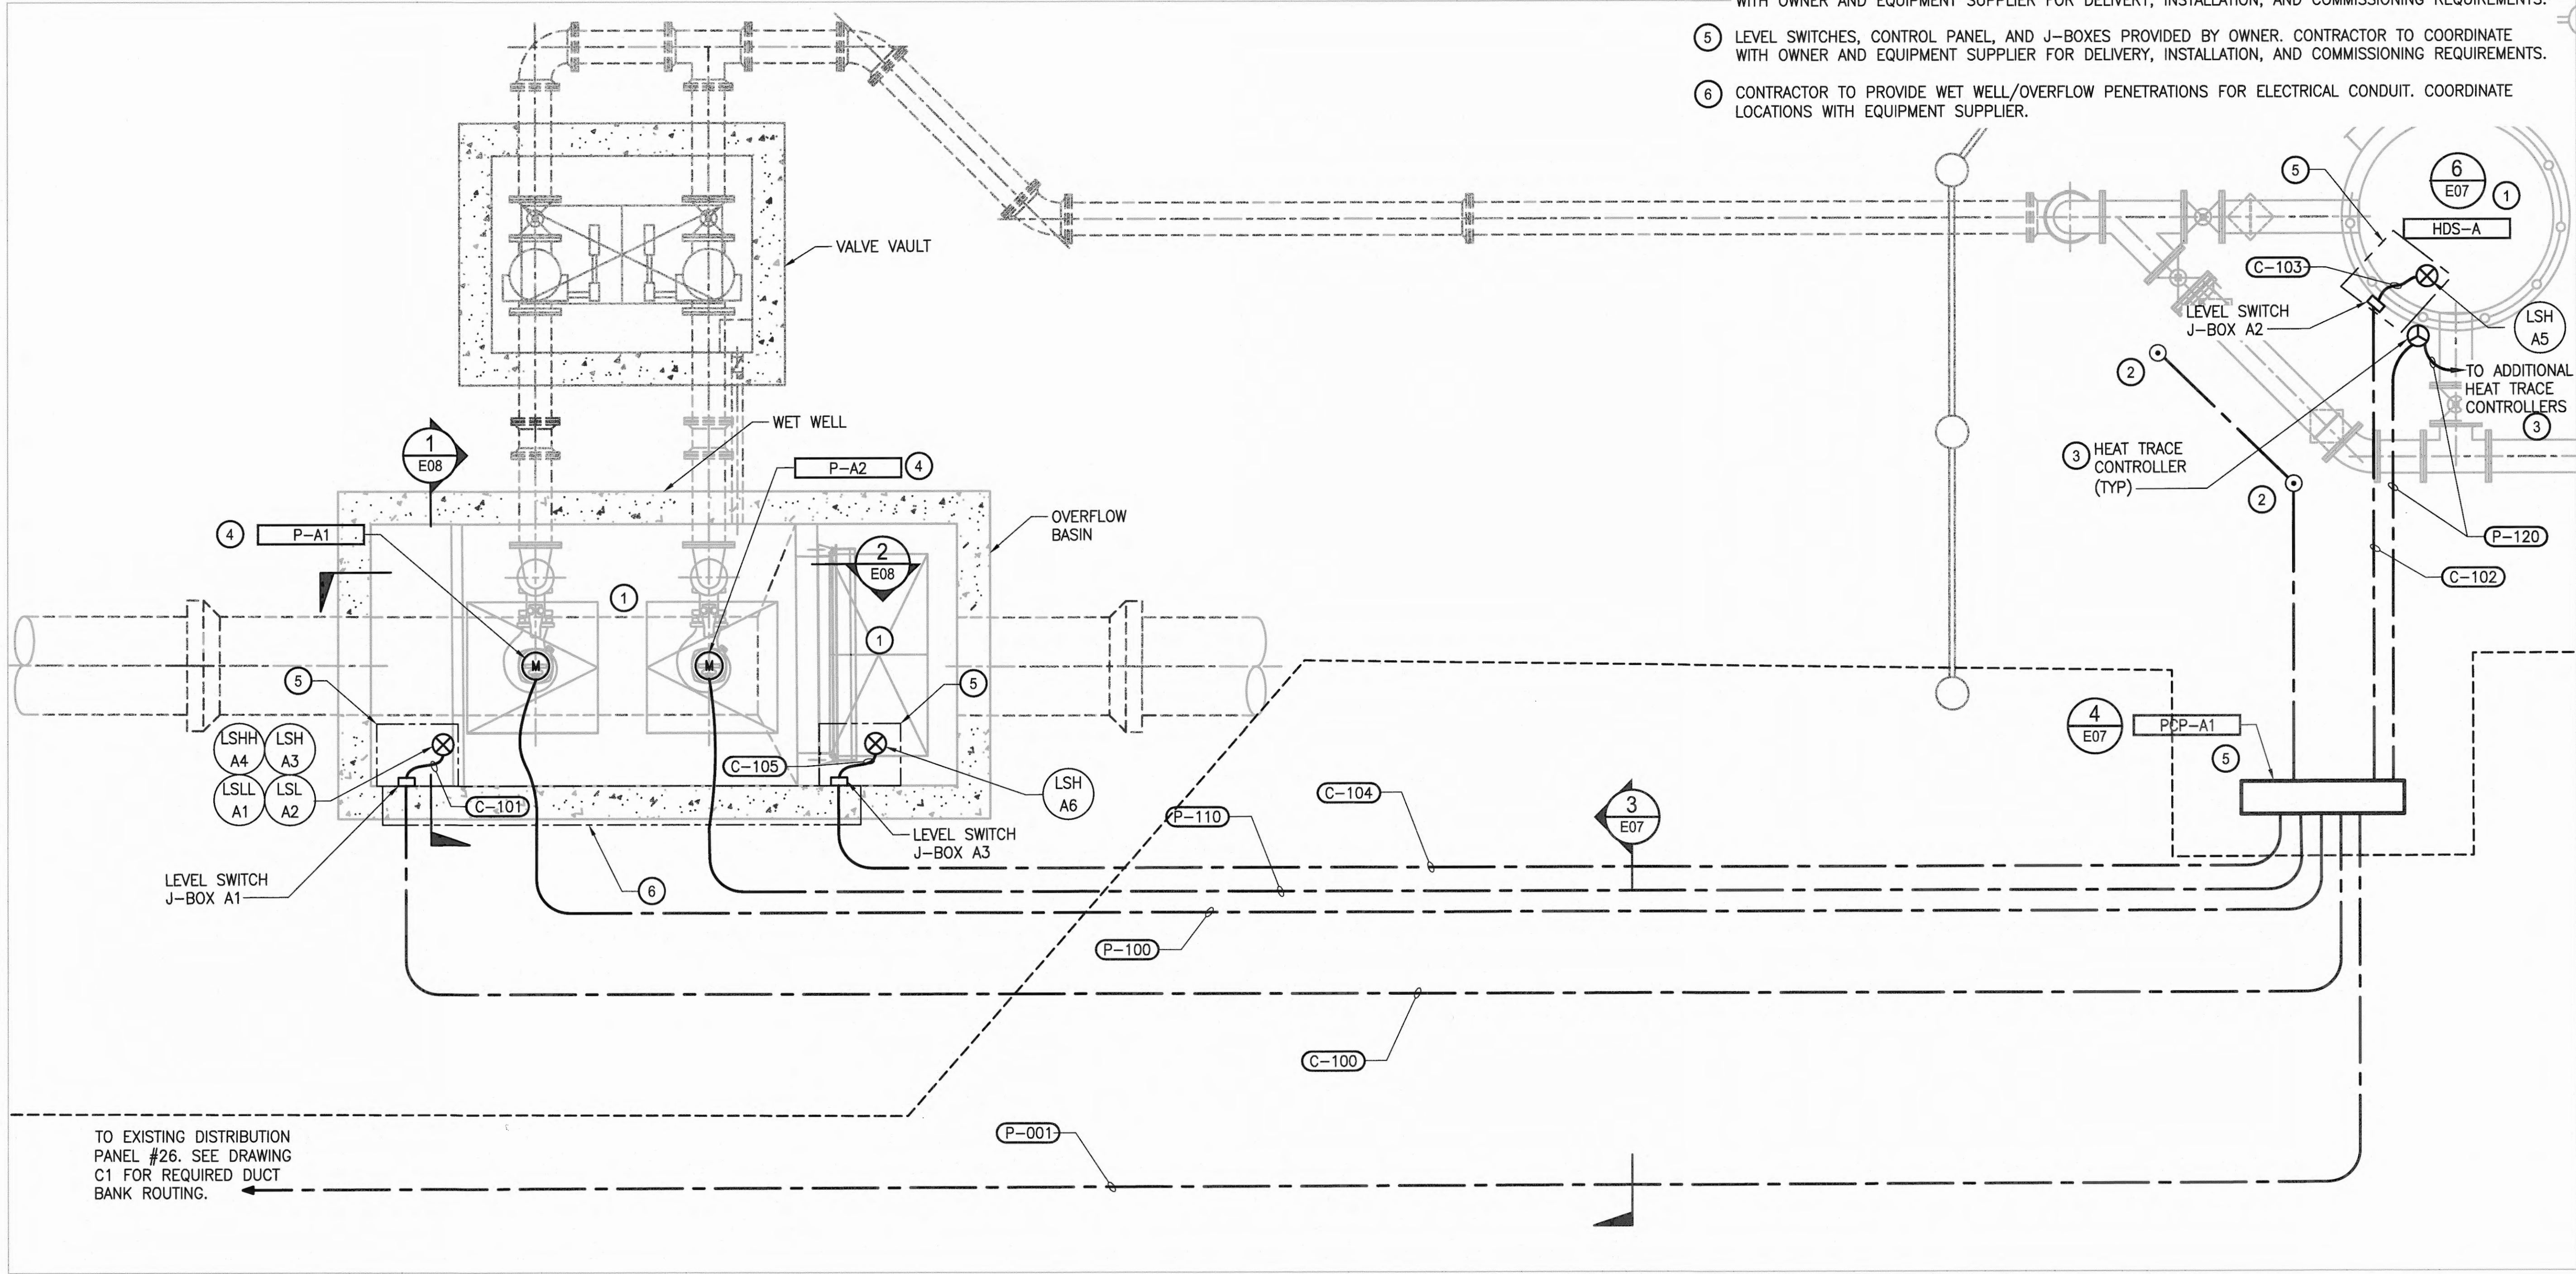


NOTES:

- 1 NATIONAL ELECTRIC CODE CLASS 1, DIVISION 2, GROUP D HAZARDOUS AREA. ALL EQUIPMENT SHALL BE RATED ACCORDINGLY.
- 2 PROVIDE #2/0 BARE COPPER GROUNDING CONDUCTOR. ATTACH TO GROUND RODS PER DETAIL 1 E07
- 3 PROVIDE HEAT TRACING TO FIVE AREAS. SEE MECHANICAL PLANS FOR EXACT LOCATIONS. LOCATE CONTROLLER(S) IN LOCATIONS THAT DO NOT INTERFERE WITH OPERATION AND MAINTENANCE. PROVIDE COMPLETE HEAT TRACING SYSTEM DESIGN. DAISY-CHAIN CONTROLLERS TOGETHER AS NEEDED. PROVIDE REQUIRED GROUND FAULT PROTECTION FOR HEAT TRACE CIRCUITS PER NEC REQUIREMENTS.
- 4 MOTORS AND PUMP POWER AND CONTROL CABLES PROVIDED BY OWNER. CONTRACTOR TO COORDINATE WITH OWNER AND EQUIPMENT SUPPLIER FOR DELIVERY, INSTALLATION, AND COMMISSIONING REQUIREMENTS.
- 5 LEVEL SWITCHES, CONTROL PANEL, AND J-BOXES PROVIDED BY OWNER. CONTRACTOR TO COORDINATE WITH OWNER AND EQUIPMENT SUPPLIER FOR DELIVERY, INSTALLATION, AND COMMISSIONING REQUIREMENTS.
- 6 CONTRACTOR TO PROVIDE WET WELL/OVERFLOW PENETRATIONS FOR ELECTRICAL CONDUIT. COORDINATE LOCATIONS WITH EQUIPMENT SUPPLIER.

ELECTRICAL SITE PLAN - BASIN A
SCALE: 3/8" = 1'-0"

6583 E04 SH 41 OF 47	WEST SITCUM STORMWATER TREATMENT ELECTRICAL SITE PLAN - BASIN A				APPROVED: <i>[Signature]</i> 4/26/18	CHECKED BY: JEM DATE: APR 25, 2018
	CONTR/CONS: 070664 M. ID: 201024.01 PHASE: BID SET	TOWNSHIP: 21N RANGE: 3E DAT-HRZ: WA83-S PARCEL: SEE G02	SECTIONS: 33 & 34 RANGE: 3E VERT: MLW DRAWING SCALE: AS NOTED	PRINTED BY: peterden DATE: APR 25, 2018 PORT ADDRESS: ONE SITCUM PLAZA TACOMA, WA 98401-1837	PROJECT: WEST SITCUM STORMWATER TREATMENT DATE: APR 25, 2018 BY: REVISION: MARK: DATE:	

THIS DRAWING IS THE PROPERTY OF THE PORT OF TACOMA AND SHALL NOT BE USED ON OTHER WORK, DISCLOSED, COPIED, IN WHOLE OR IN PART, WITHOUT WRITTEN PERMISSION

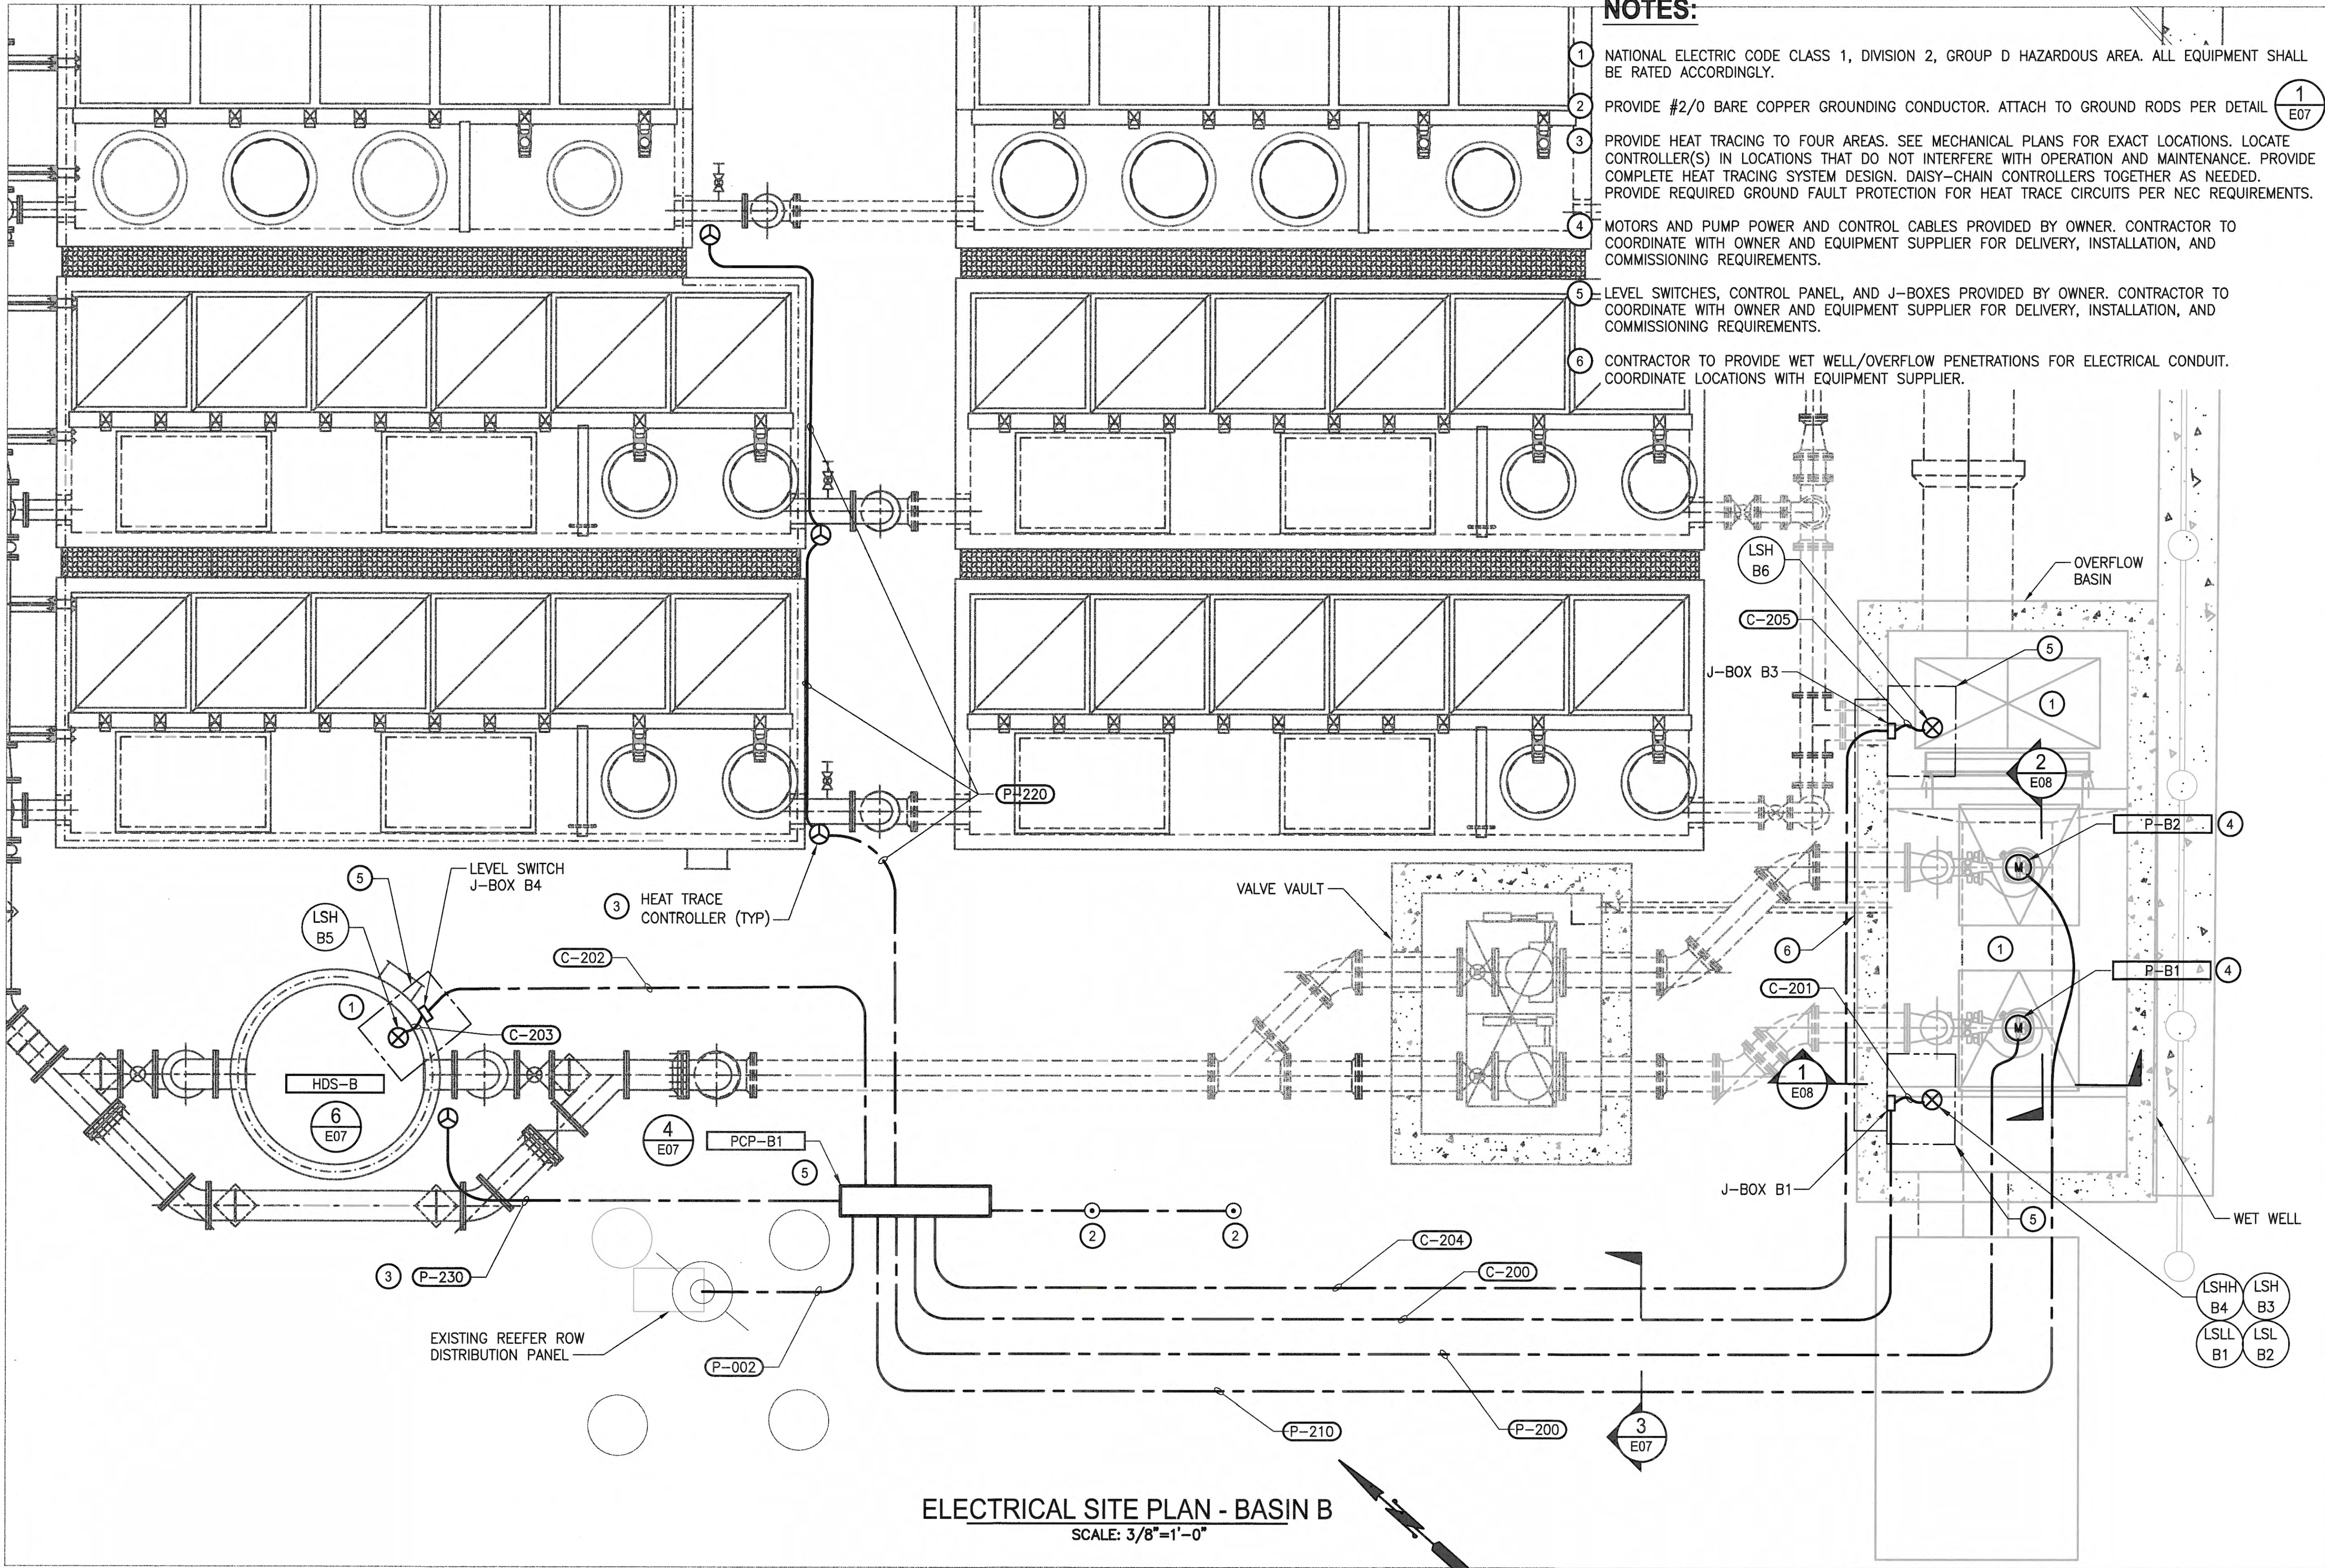

- NOTES:**
- 1 NATIONAL ELECTRIC CODE CLASS 1, DIVISION 2, GROUP D HAZARDOUS AREA. ALL EQUIPMENT SHALL BE RATED ACCORDINGLY.
 - 2 PROVIDE #2/0 BARE COPPER GROUNDING CONDUCTOR. ATTACH TO GROUND RODS PER DETAIL 1 E07
 - 3 PROVIDE HEAT TRACING TO FOUR AREAS. SEE MECHANICAL PLANS FOR EXACT LOCATIONS. LOCATE CONTROLLER(S) IN LOCATIONS THAT DO NOT INTERFERE WITH OPERATION AND MAINTENANCE. PROVIDE COMPLETE HEAT TRACING SYSTEM DESIGN. DAISY-CHAIN CONTROLLERS TOGETHER AS NEEDED. PROVIDE REQUIRED GROUND FAULT PROTECTION FOR HEAT TRACE CIRCUITS PER NEC REQUIREMENTS.
 - 4 MOTORS AND PUMP POWER AND CONTROL CABLES PROVIDED BY OWNER. CONTRACTOR TO COORDINATE WITH OWNER AND EQUIPMENT SUPPLIER FOR DELIVERY, INSTALLATION, AND COMMISSIONING REQUIREMENTS.
 - 5 LEVEL SWITCHES, CONTROL PANEL, AND J-BOXES PROVIDED BY OWNER. CONTRACTOR TO COORDINATE WITH OWNER AND EQUIPMENT SUPPLIER FOR DELIVERY, INSTALLATION, AND COMMISSIONING REQUIREMENTS.
 - 6 CONTRACTOR TO PROVIDE WET WELL/OVERFLOW PENETRATIONS FOR ELECTRICAL CONDUIT. COORDINATE LOCATIONS WITH EQUIPMENT SUPPLIER.

6583
E05
SH 42 OF 47

CONTR/CONS: 070664
M. ID: 201024.01
PHASE: BID SET

WEST SITCUM
STORMWATER TREATMENT
ELECTRICAL SITE PLAN - BASIN B

TOWNSHIP: 21N
RANGE: 3E
SECTION: 33 & 34
DATE-HRZ: WAB3-S
PARCEL: SEE G02

DRAWING SCALE: AS NOTED

APPROVED: *[Signature]*
DIRECTOR
4/26/18

AGS MAR 2018
CHECKED BY: JEM
DATE: APR 2018


PRINTED BY: peterden
DATE: Apr 25, 2018
PORT ADDRESS: ONE SITCUM PLAZA
TACOMA, WA 98401-1837

Parametrix
ENGINEERING, PLANNING, ENVIRONMENTAL SCIENCES
60 WASHINGTON AVENUE, SUITE 390
SEASIDE, WA 98137
WWW.PARAMETRIX.COM

APPR: DATE:
BY:
REVISION:
MARK:

Port of Tacoma
P.O. BOX 1837 TACOMA, WA 98401-1837

APRIL 25, 2018

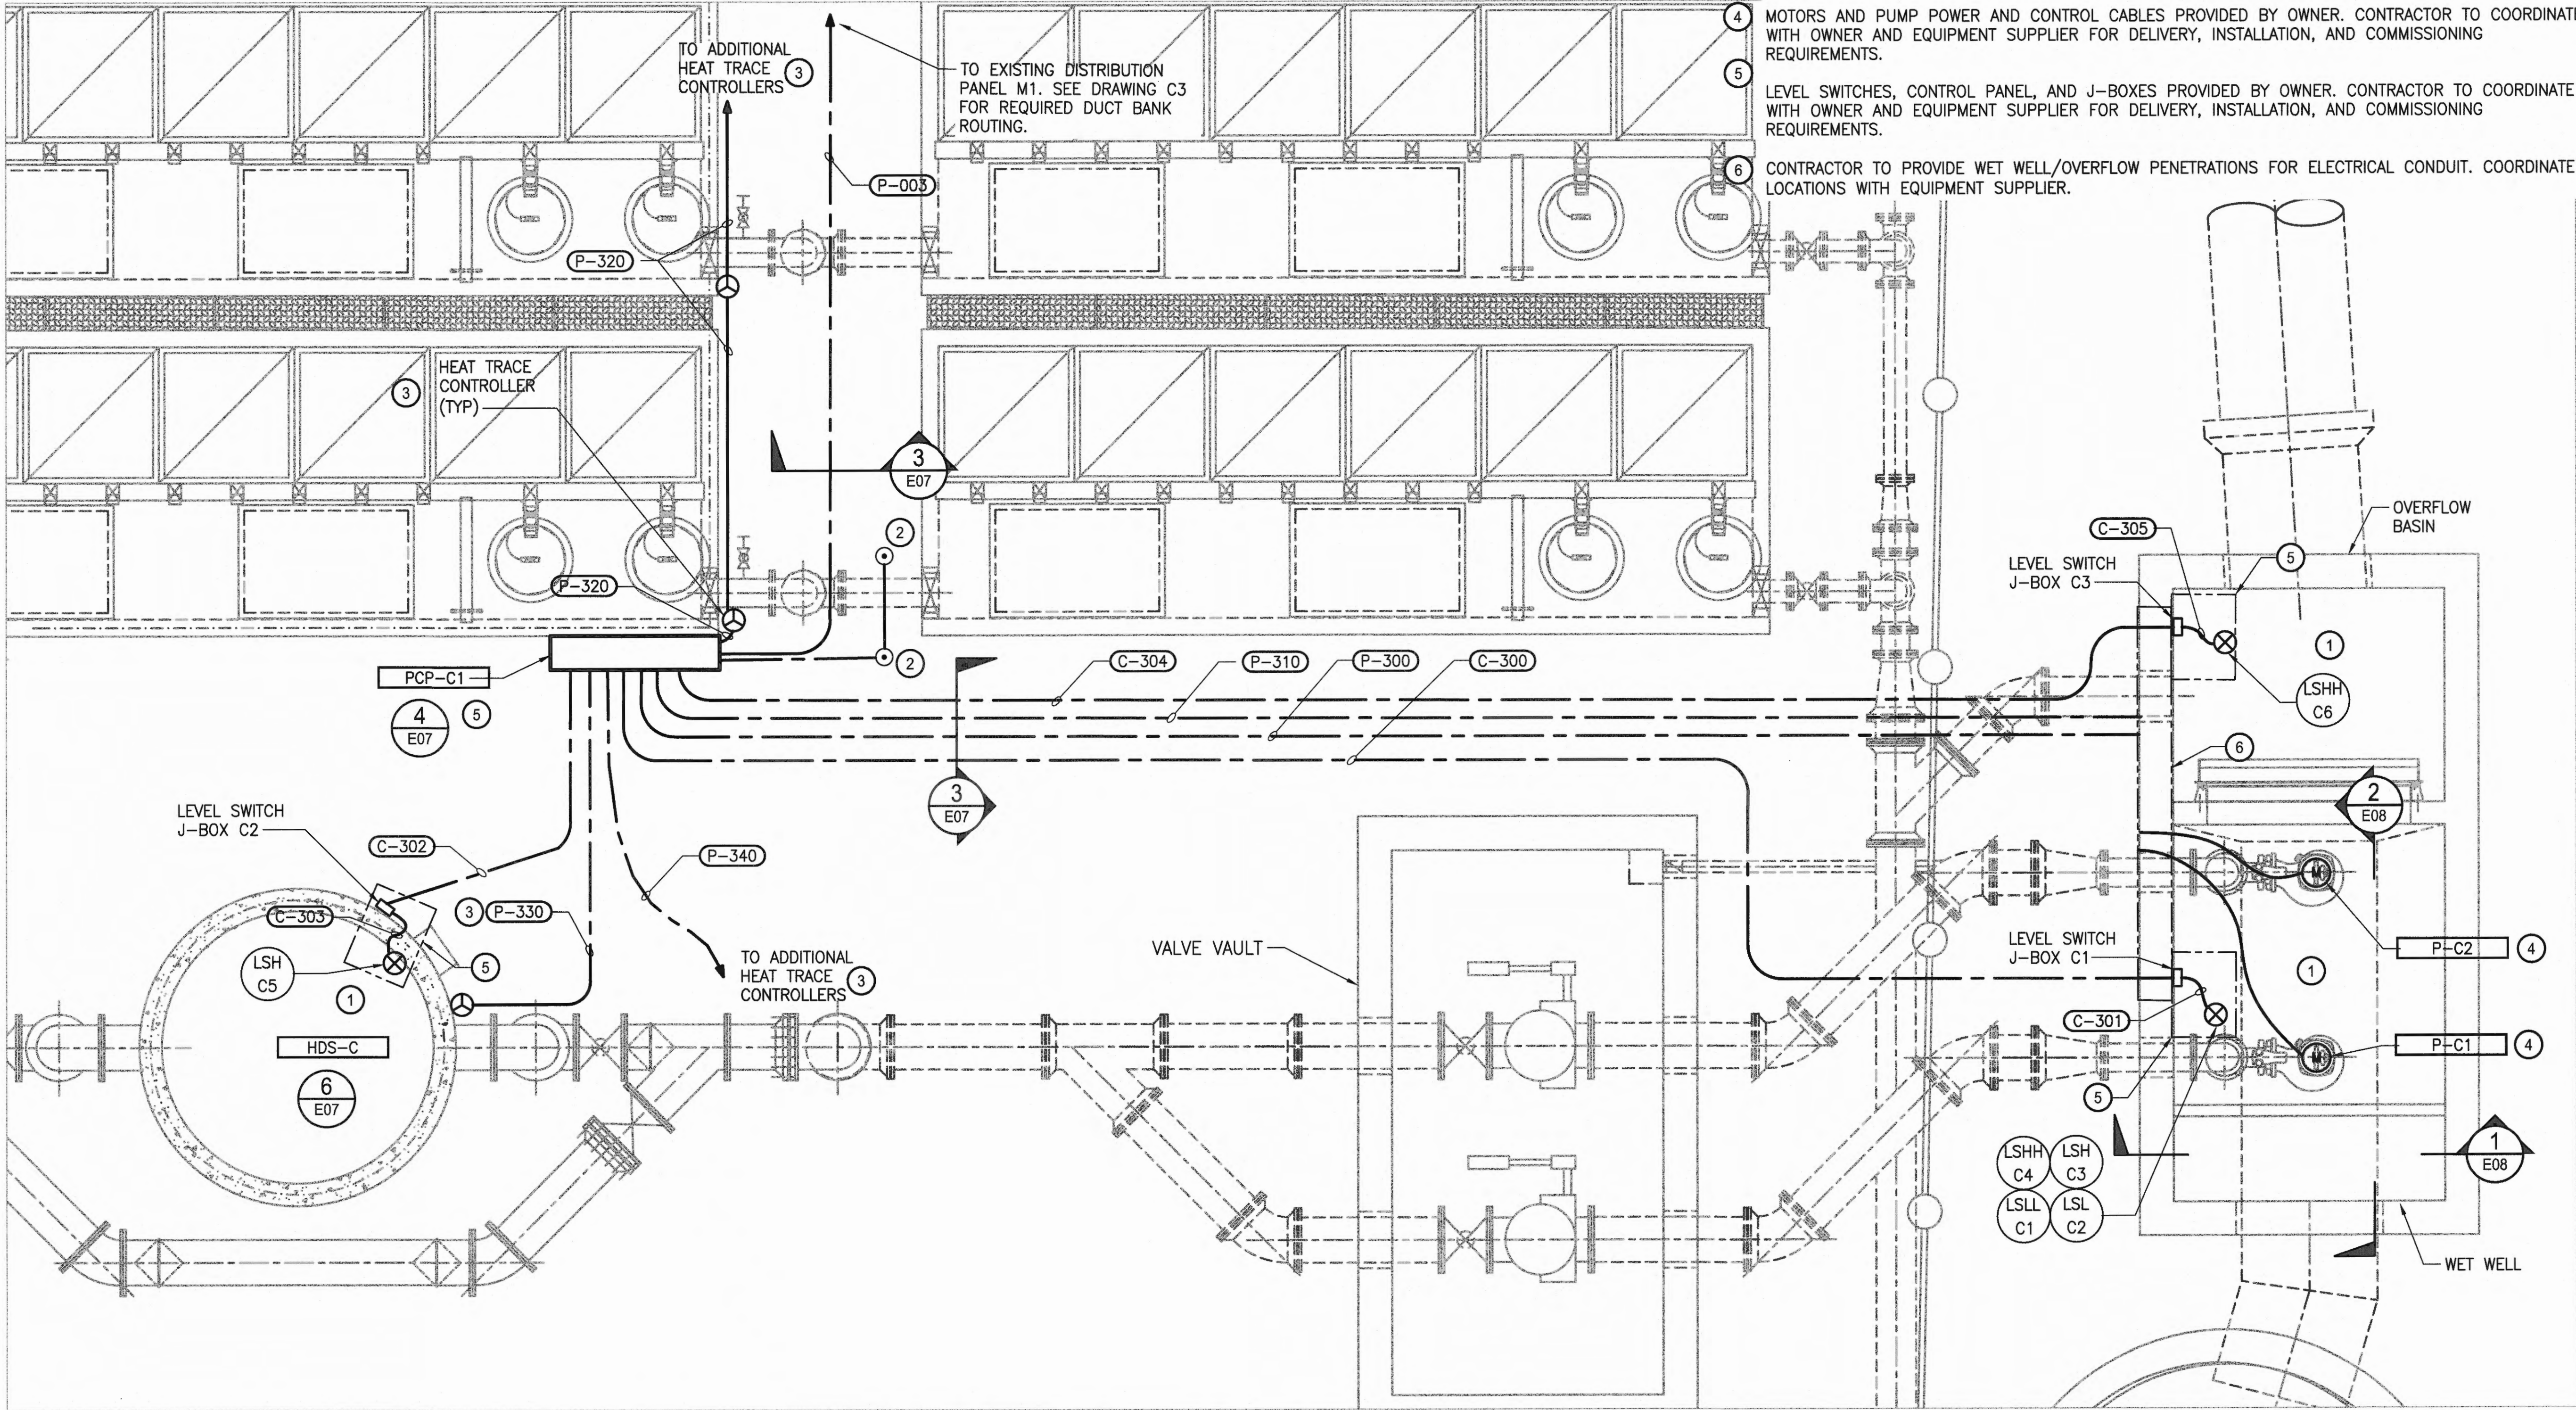


ELECTRICAL SITE PLAN - BASIN C
SCALE: 3/8" = 1'-0"

NOTES:


- 1 NATIONAL ELECTRIC CODE CLASS 1, DIVISION 2, GROUP D HAZARDOUS AREA. ALL EQUIPMENT SHALL BE RATED ACCORDINGLY.
- 2 PROVIDE #2/0 BARE COPPER GROUNDING CONDUCTOR. ATTACH TO GROUND RODS PER DETAIL 1 E07
- 3 PROVIDE HEAT TRACING TO SEVEN AREAS. SEE MECHANICAL PLANS FOR EXACT LOCATIONS. LOCATE CONTROLLER(S) IN LOCATIONS THAT DO NOT INTERFERE WITH OPERATION AND MAINTENANCE. PROVIDE COMPLETE HEAT TRACING SYSTEM DESIGN. DAISY-CHAIN CONTROLLERS TOGETHER AS NEEDED. PROVIDE REQUIRED GROUND FAULT PROTECTION FOR HEAT TRACE CIRCUITS PER NEC REQUIREMENTS.
- 4 MOTORS AND PUMP POWER AND CONTROL CABLES PROVIDED BY OWNER. CONTRACTOR TO COORDINATE WITH OWNER AND EQUIPMENT SUPPLIER FOR DELIVERY, INSTALLATION, AND COMMISSIONING REQUIREMENTS.
- 5 LEVEL SWITCHES, CONTROL PANEL, AND J-BOXES PROVIDED BY OWNER. CONTRACTOR TO COORDINATE WITH OWNER AND EQUIPMENT SUPPLIER FOR DELIVERY, INSTALLATION, AND COMMISSIONING REQUIREMENTS.
- 6 CONTRACTOR TO PROVIDE WET WELL/OVERFLOW PENETRATIONS FOR ELECTRICAL CONDUIT. COORDINATE LOCATIONS WITH EQUIPMENT SUPPLIER.

6583 E06 SH 43 OF 47 CONT/CONS: 070664 M. ID: 201024.01 PHASE: BID SET	WEST SITCUM STORMWATER TREATMENT ELECTRICAL SITE PLAN - BASIN C		APPROVED: <i>John L. Anderson</i> 4/25/18	AGS MAR 2018 CHECKED BY: JEM DATE: APR 2018	 Parametrix ENGINEERING & ENVIRONMENTAL SCIENCES 20 WASHINGTON AVENUE, SUITE 390 BREMERTON, WA 98337 P 360.377.0014 WWW.PARAMETRIX.COM	 Parametrix ENGINEERING & ENVIRONMENTAL SCIENCES 20 WASHINGTON AVENUE, SUITE 390 BREMERTON, WA 98337 P 360.377.0014 WWW.PARAMETRIX.COM	DATE: _____
	TOWNSHIP: 21N RANGE: 3E SECTION: 33 & 34 VERT: MLLW DAT-HRZ: WA83-S PARCEL: SEE G02	PRINTED BY: peter den DATE: APR 25, 2018 PORT ADDRESS: ONE SITCUM PLAZA TACOMA, WA 98401-1837	BY: _____ REVISION: _____	APPR: _____			


THIS DRAWING IS THE PROPERTY OF THE PORT OF TACOMA AND SHALL NOT BE USED ON OTHER WORK, DISCLOSED, COPIED, IN WHOLE OR IN PART, WITHOUT WRITTEN PERMISSION

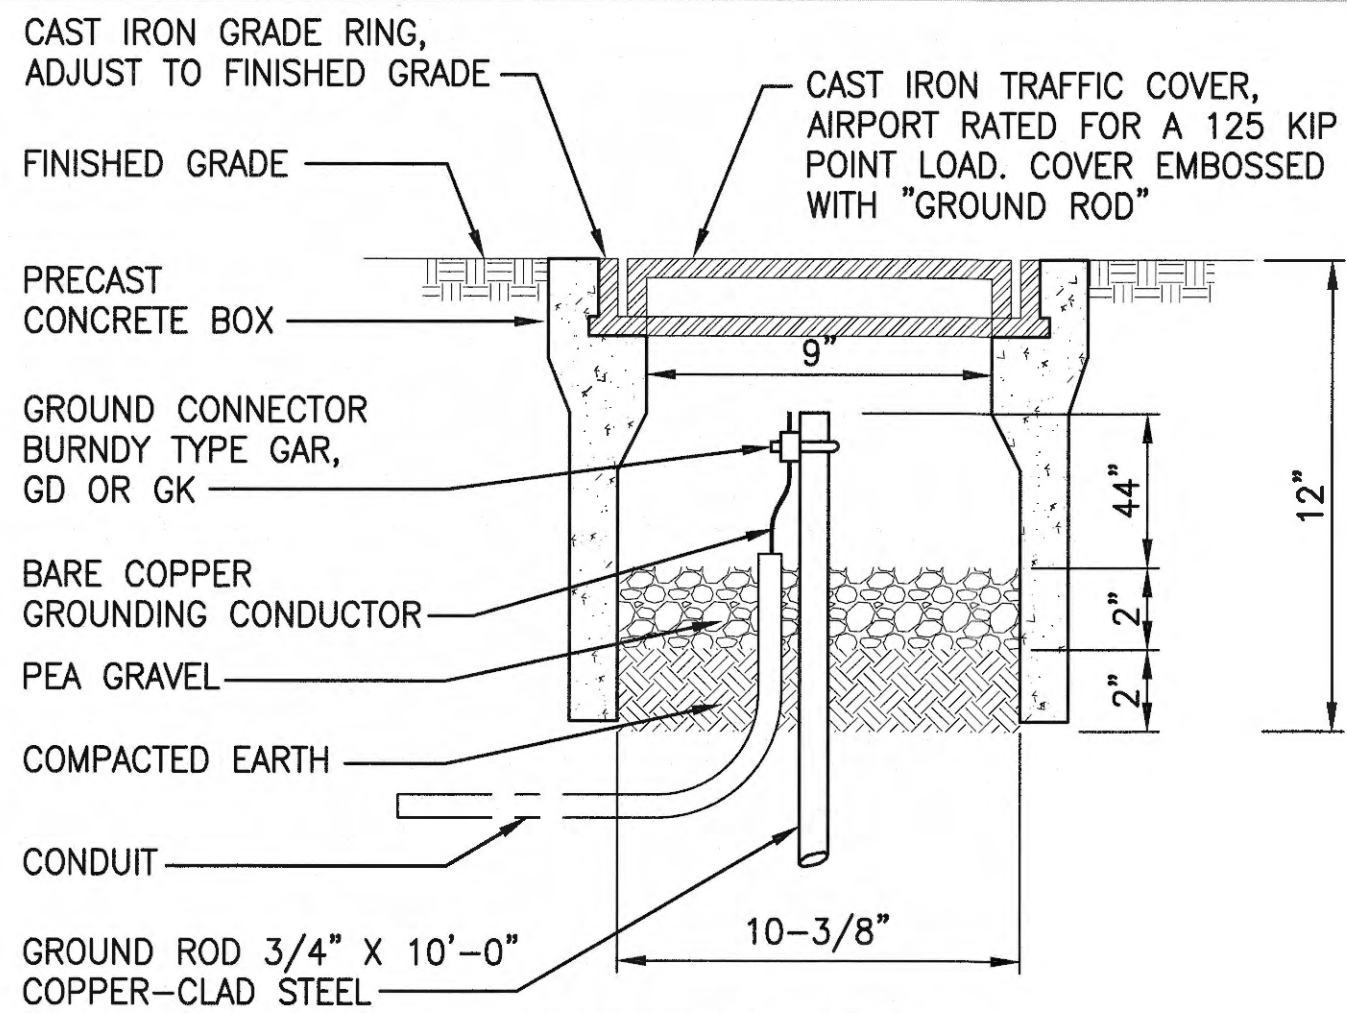


1
GROUND ROD BOX DETAIL
SCALE: NOT TO SCALE

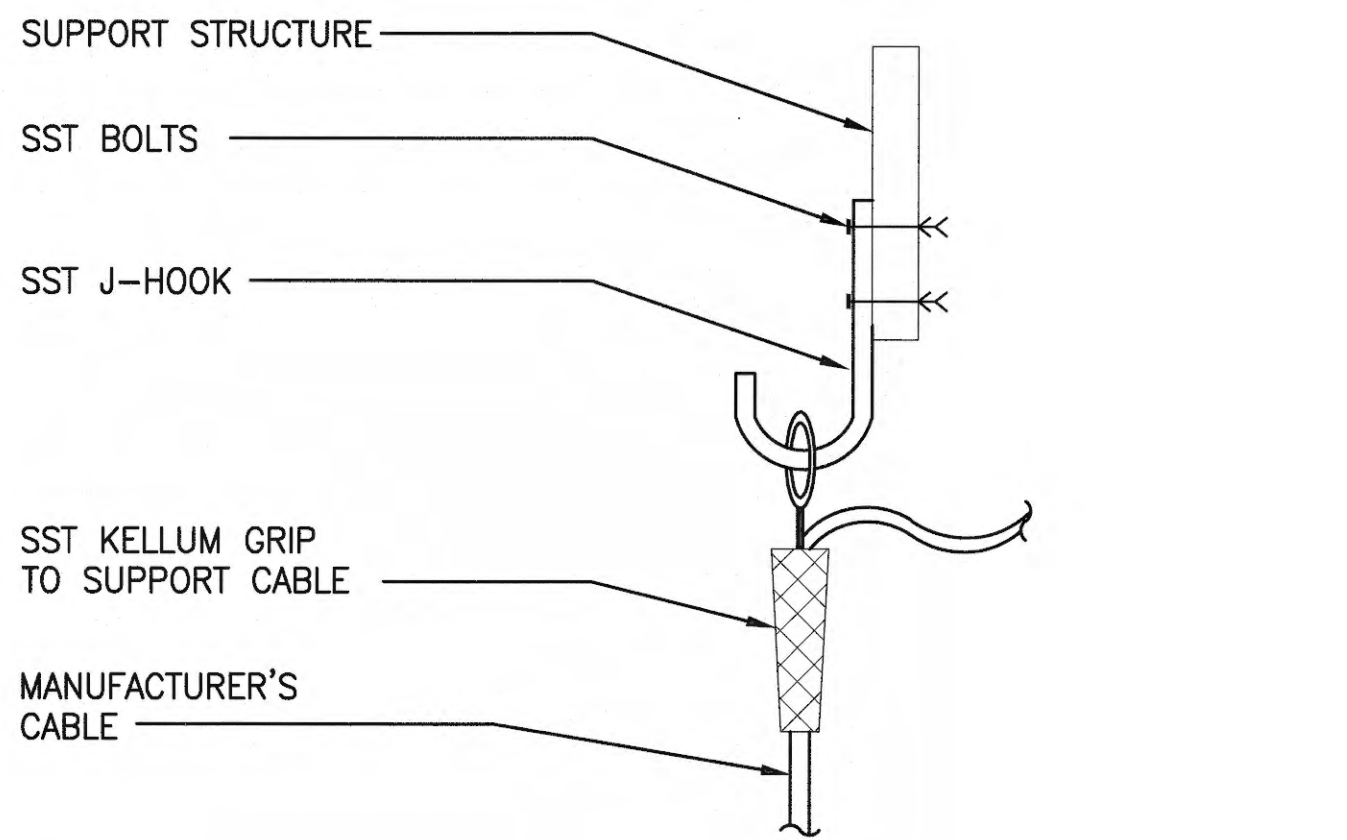


2
KELLUM GRIP CABLE SUPPORT DETAIL
SCALE: NOT TO SCALE

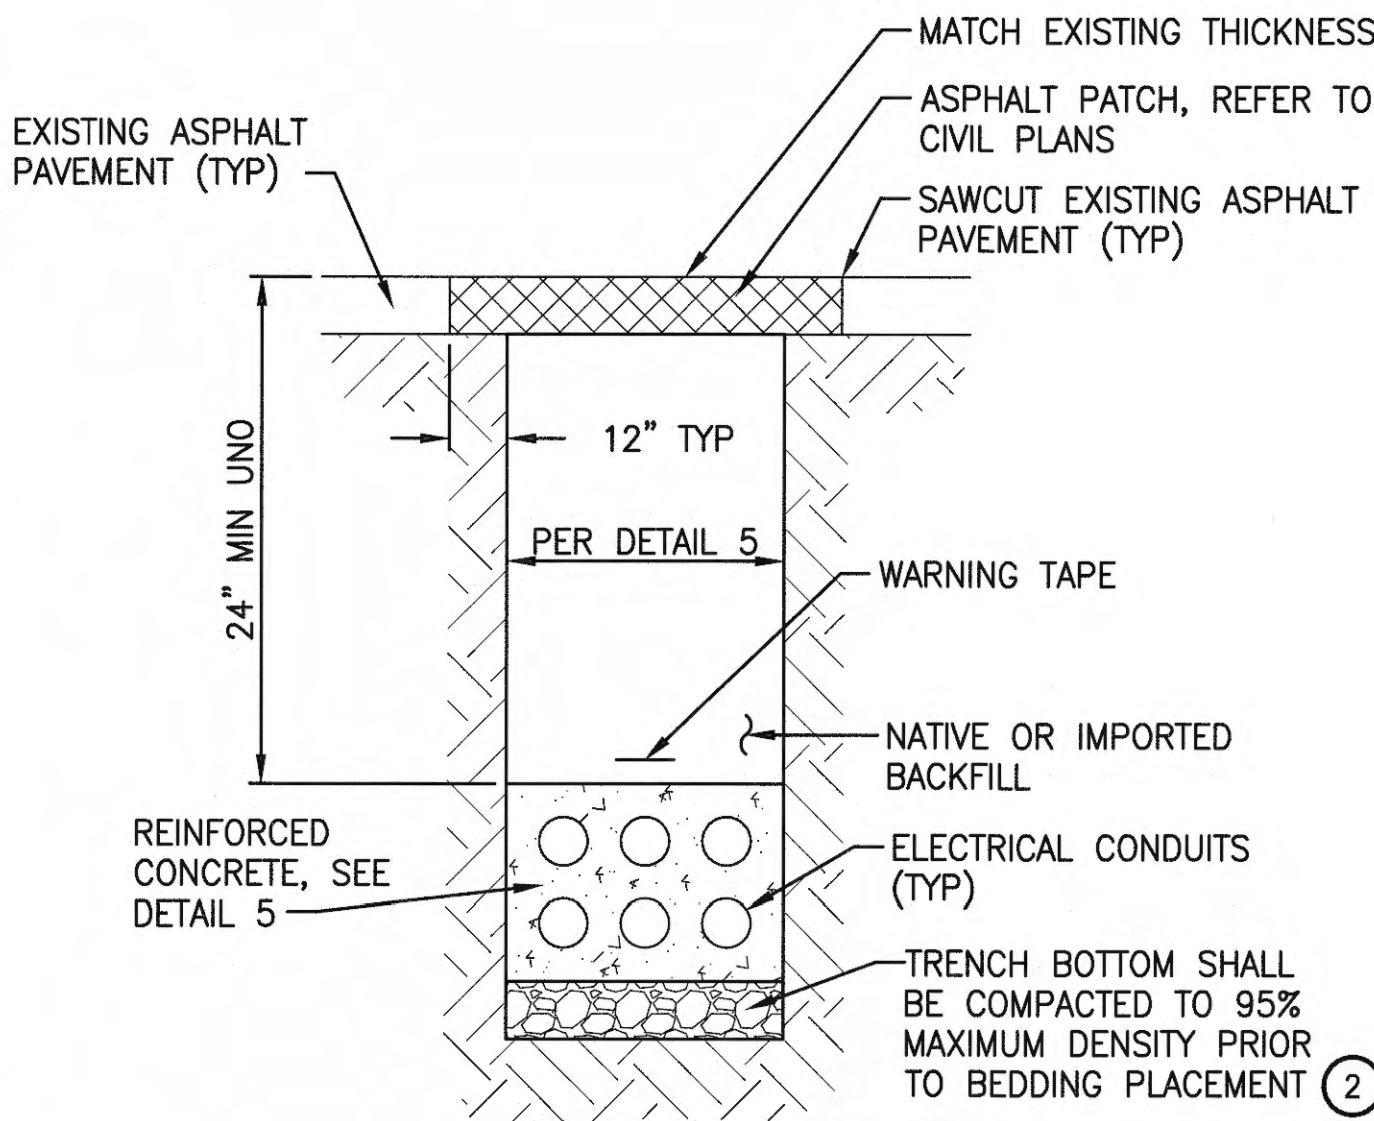

3
TYPICAL TRENCH DETAIL
SCALE: NOT TO SCALE

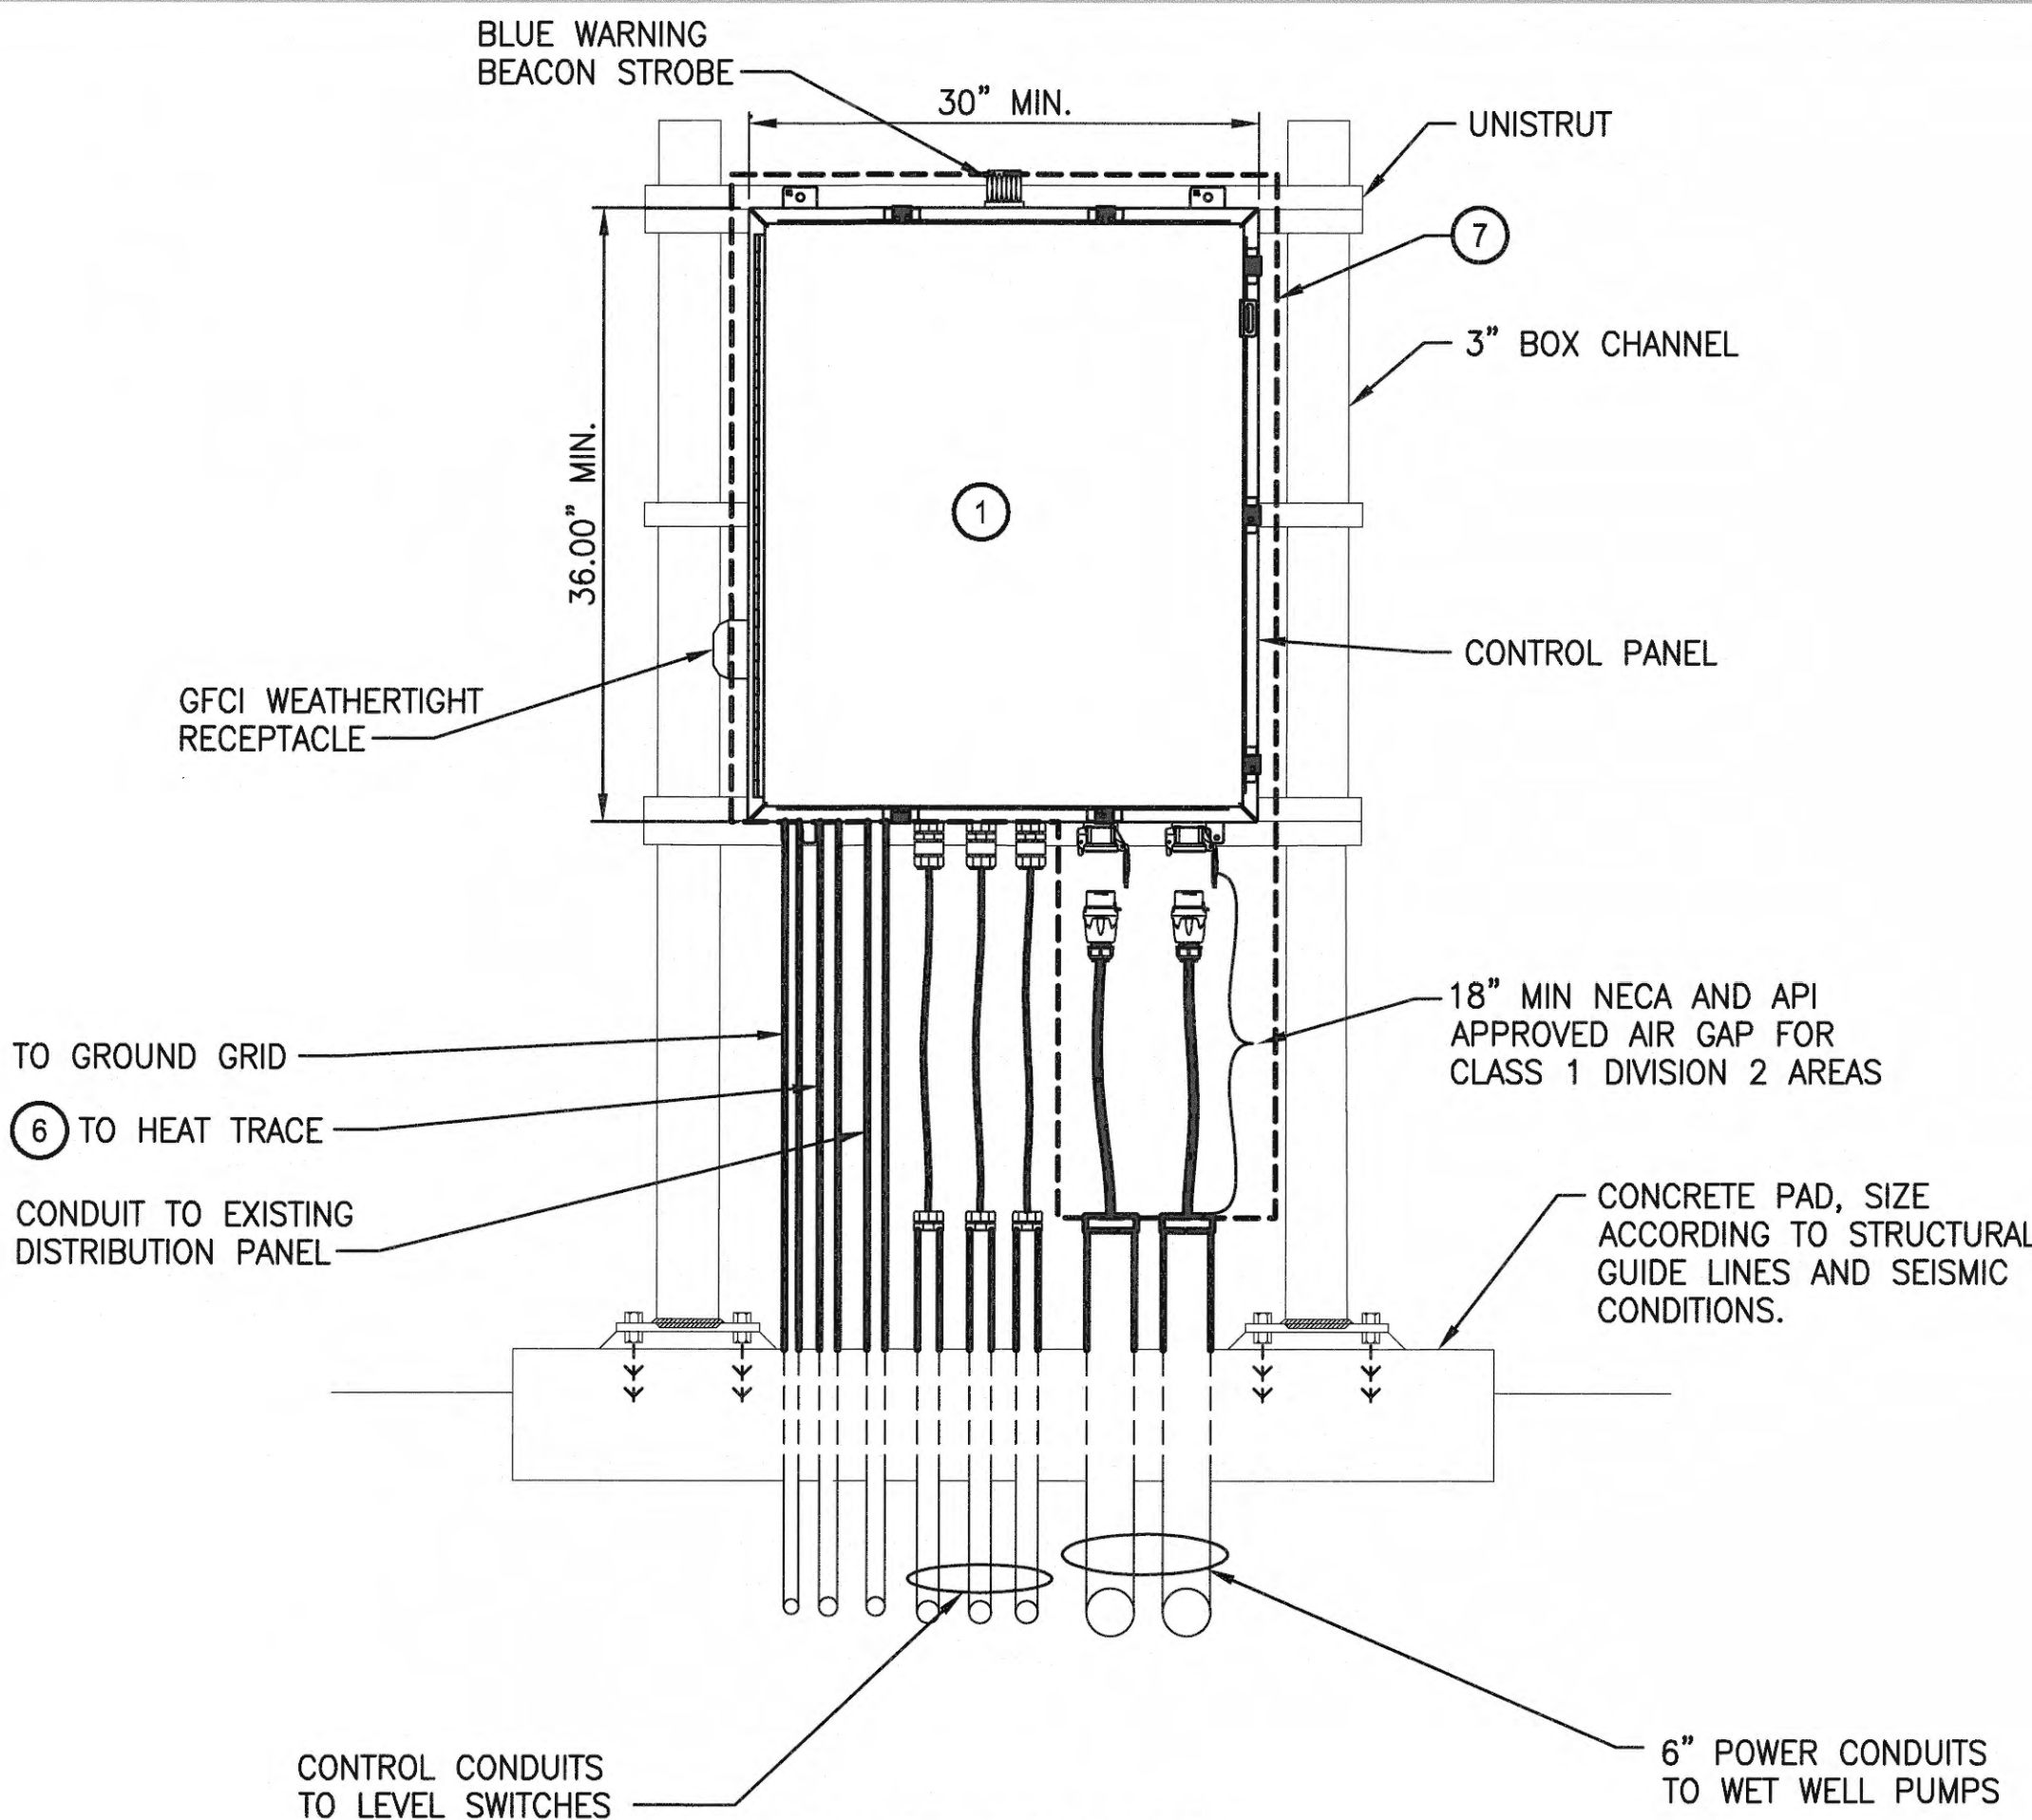


4
PUMP CONTROL PANEL DETAIL
SCALE: NOT TO SCALE

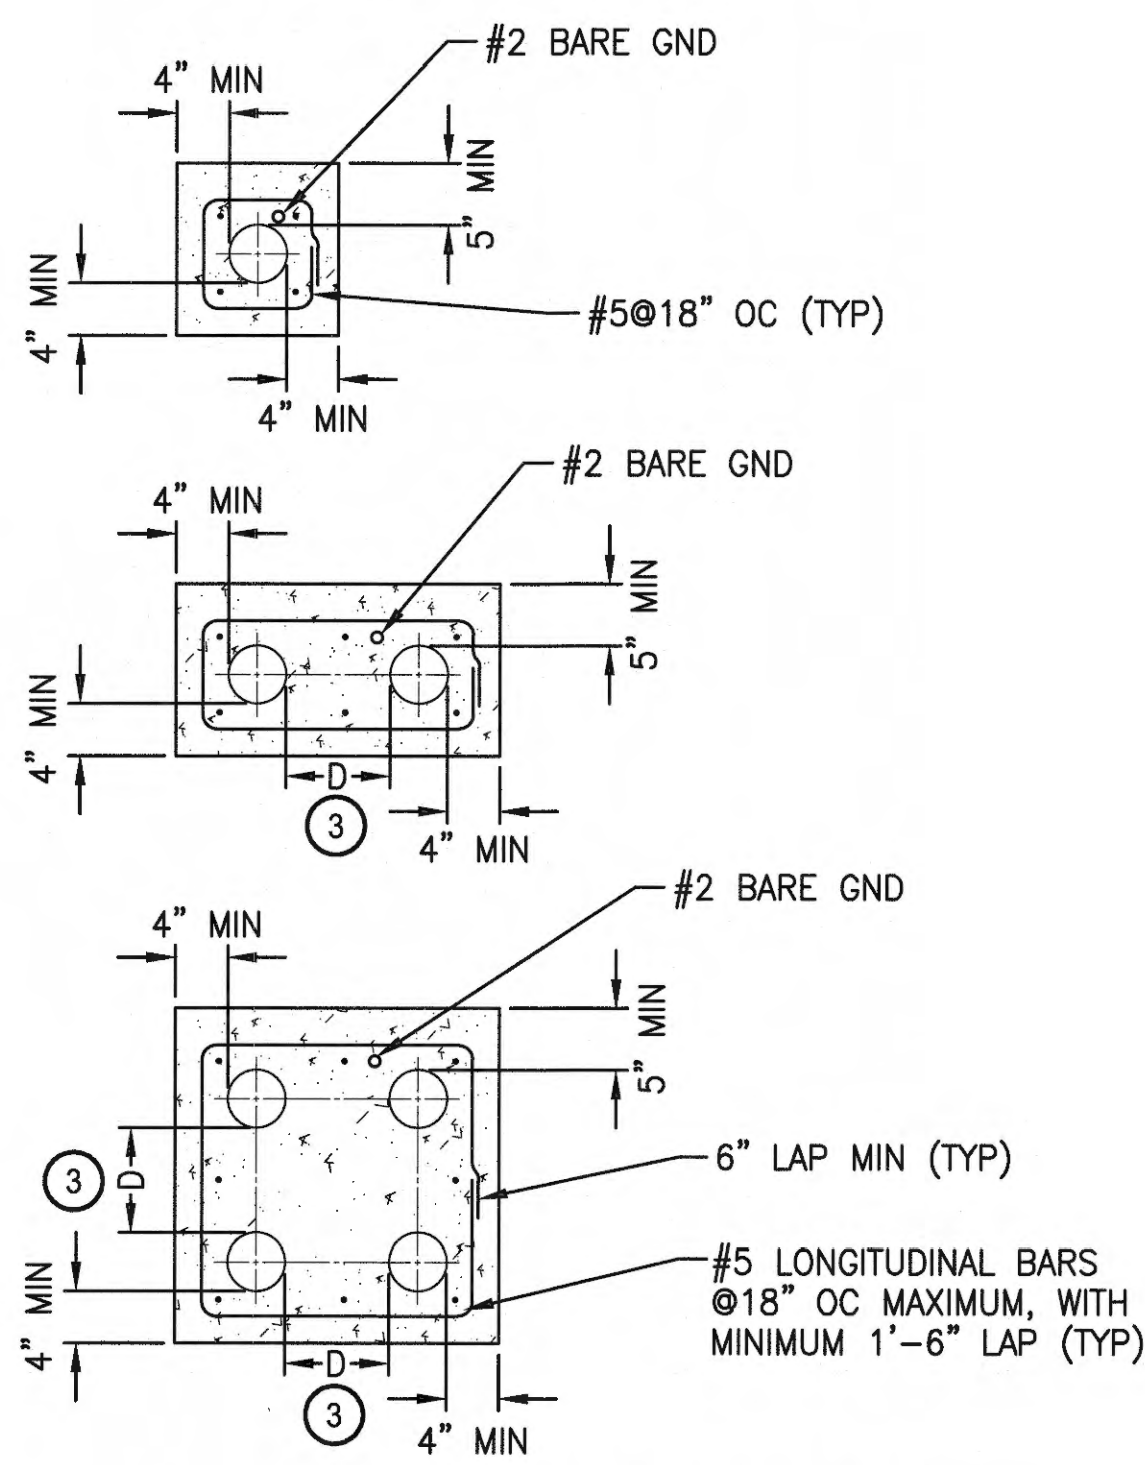

5
TYPICAL DUCTBANK DETAIL
SCALE: NOT TO SCALE

NOTES:

- 1 CONTENTS OF CONTROL PANEL COORDINATED WITH AND SUPPLIED BY PUMP MANUFACTURER.
- 2 PROVIDE 6" MINIMUM COMPACTED GRAVEL, 1/2" MINUS, UNDER ALL CONCRETE ENCASED DUCT RUNS.
- 3 D = 3" FOR 2" AND LARGER CONDUITS
D = 2" FOR CONDUITS SMALLER THAN 2"
- 4 DUCT BANK CONFIGURATION VARIES PER SITE. CONTRACTOR SHALL CONFIRM EXISTING SITE CONDITIONS AND ADJUST DUCT BANK CONFIGURATION AS NEEDED. CONFIGURATIONS SHALL BE SUBMITTED TO ENGINEER FOR APPROVAL PRIOR TO CONSTRUCTION.
- 5 LAST 24" OF DUCT BANK INTO A CLASSIFIED AREA SHALL BE PGRS PER NEC REQUIREMENTS.
- 6 MULTIPLE HEAT TRACE CIRCUITS MAY BE REQUIRED. SEE DRAWINGS E04, E05, E06, AND E08.
- 7 CONTROL PANEL AND PUMP POWER CABLES PROVIDED BY OWNER. CONTRACTOR TO COORDINATE WITH OWNER AND EQUIPMENT SUPPLIER FOR DELIVERY, INSTALLATION, AND COMMISSIONING REQUIREMENTS.

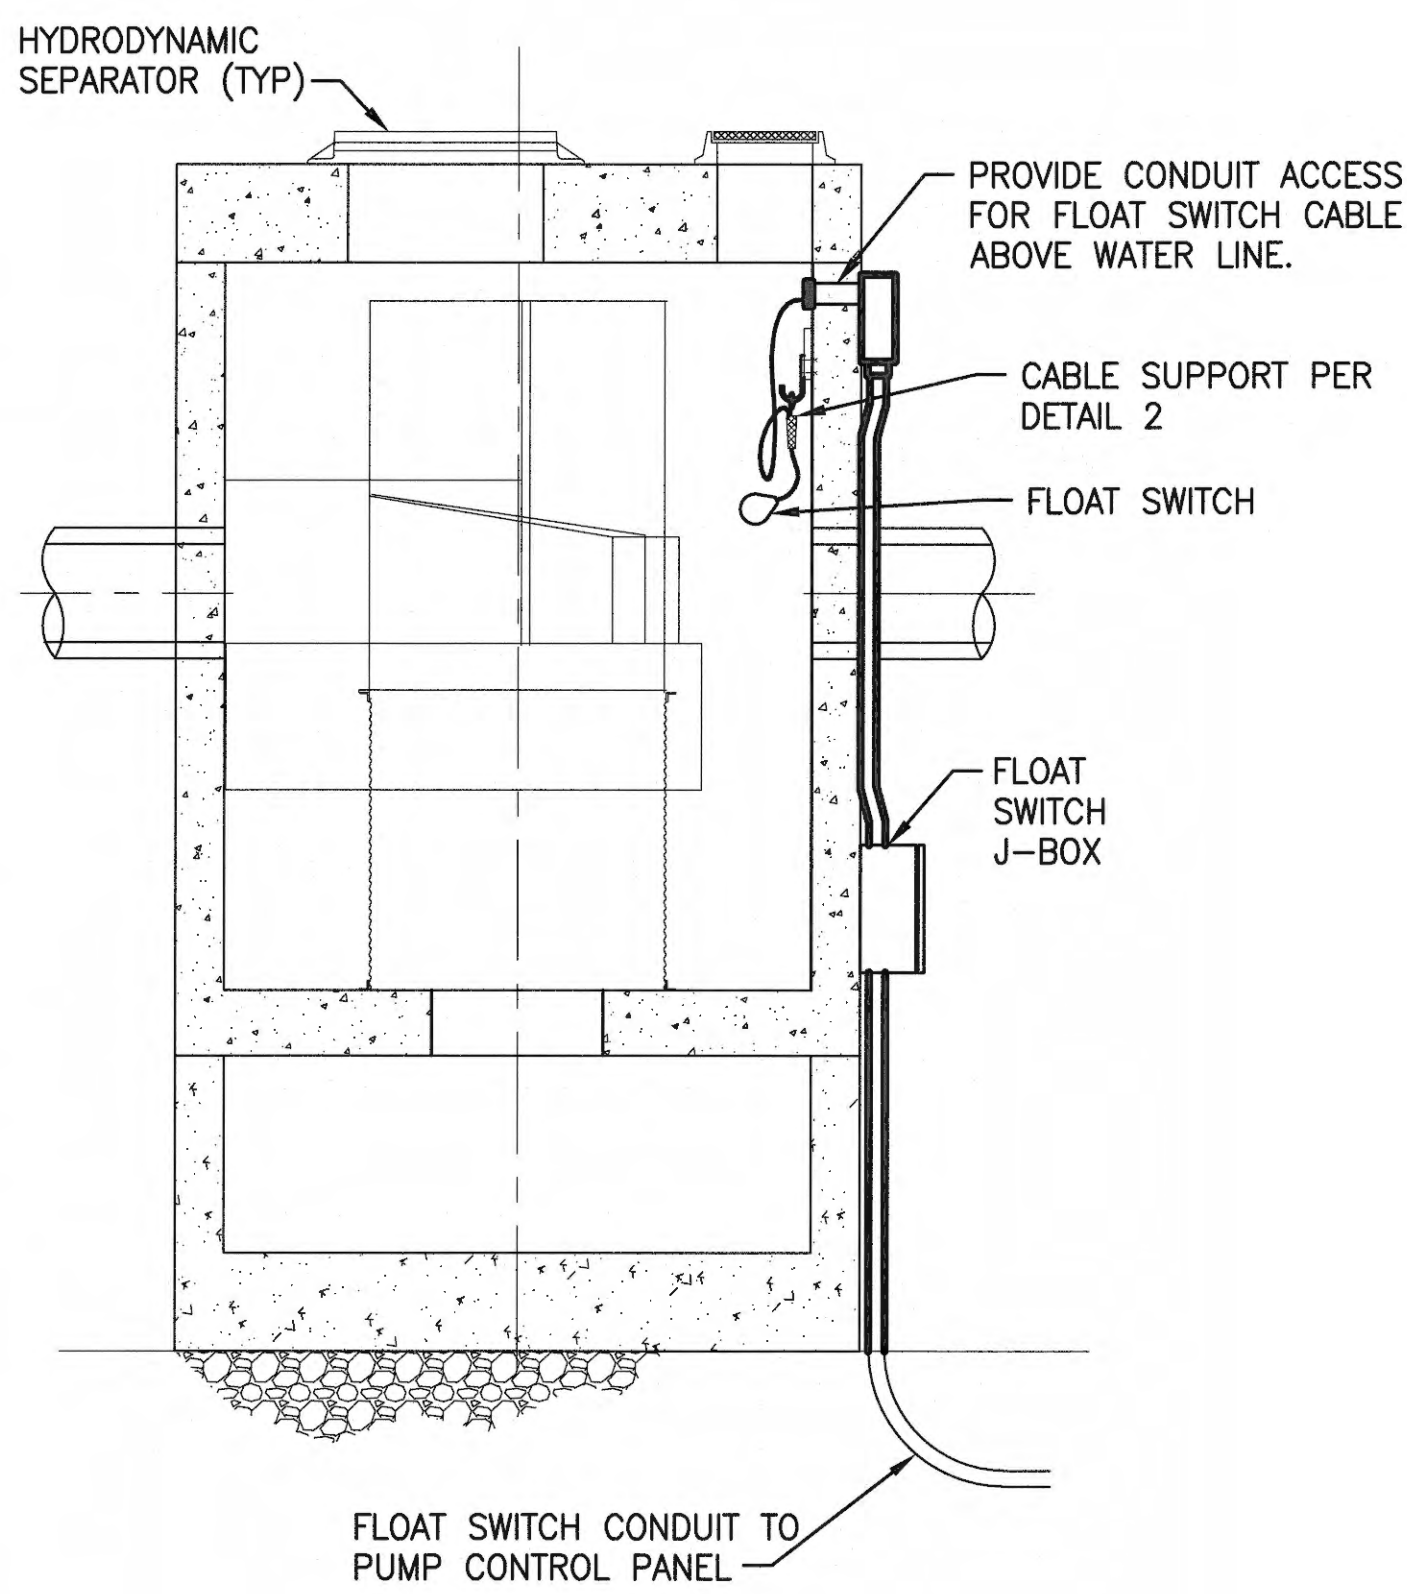


6
HYDRODYNAMIC SEPARATOR FLOAT SWITCH MOUNTING DETAIL
SCALE: NOT TO SCALE

6583 E07 SH 44 OF 47 CONT/CONS: 070664 M. ID: 201024.01 PHASE: BID SET	WEST SITCUM STORMWATER TREATMENT ELECTRICAL DETAILS - GENERAL	APPROVED: <i>[Signature]</i> DIRECTOR 4/26/18	AGS MAR 2018 CHECKED BY: JEM DATE: APR 2018	TACOMA, WA 98401-1837
		PRINTED BY: peterden DATE: Apr 25, 2018 PORT ADDRESS: ONE SITCUM PLAZA		
TOWNSHIP: 21N RANGE: 3E SECTION: 33 & 34 DAT-HRZ: WA83-S PARCEL: SEE G02		DRAWING SCALE: AS NOTED		APRIL 25, 2018

Port of Tacoma
P.O. BOX 1837 TACOMA, WA 98401 (206) 383-5441

Parametrix
ENGINEERING PLANNING ENVIRONMENTAL SCIENCES
800 WASHINGTON AVENUE, SUITE 330
TACOMA, WA 98401
P: 360.377.0014
WWW.PARAMETRIX.COM

THIS DRAWING IS THE PROPERTY OF THE PORT OF TACOMA AND SHALL NOT BE USED ON OTHER WORK, DISCLOSED, COPIED, IN WHOLE OR IN PART, WITHOUT WRITTEN PERMISSION

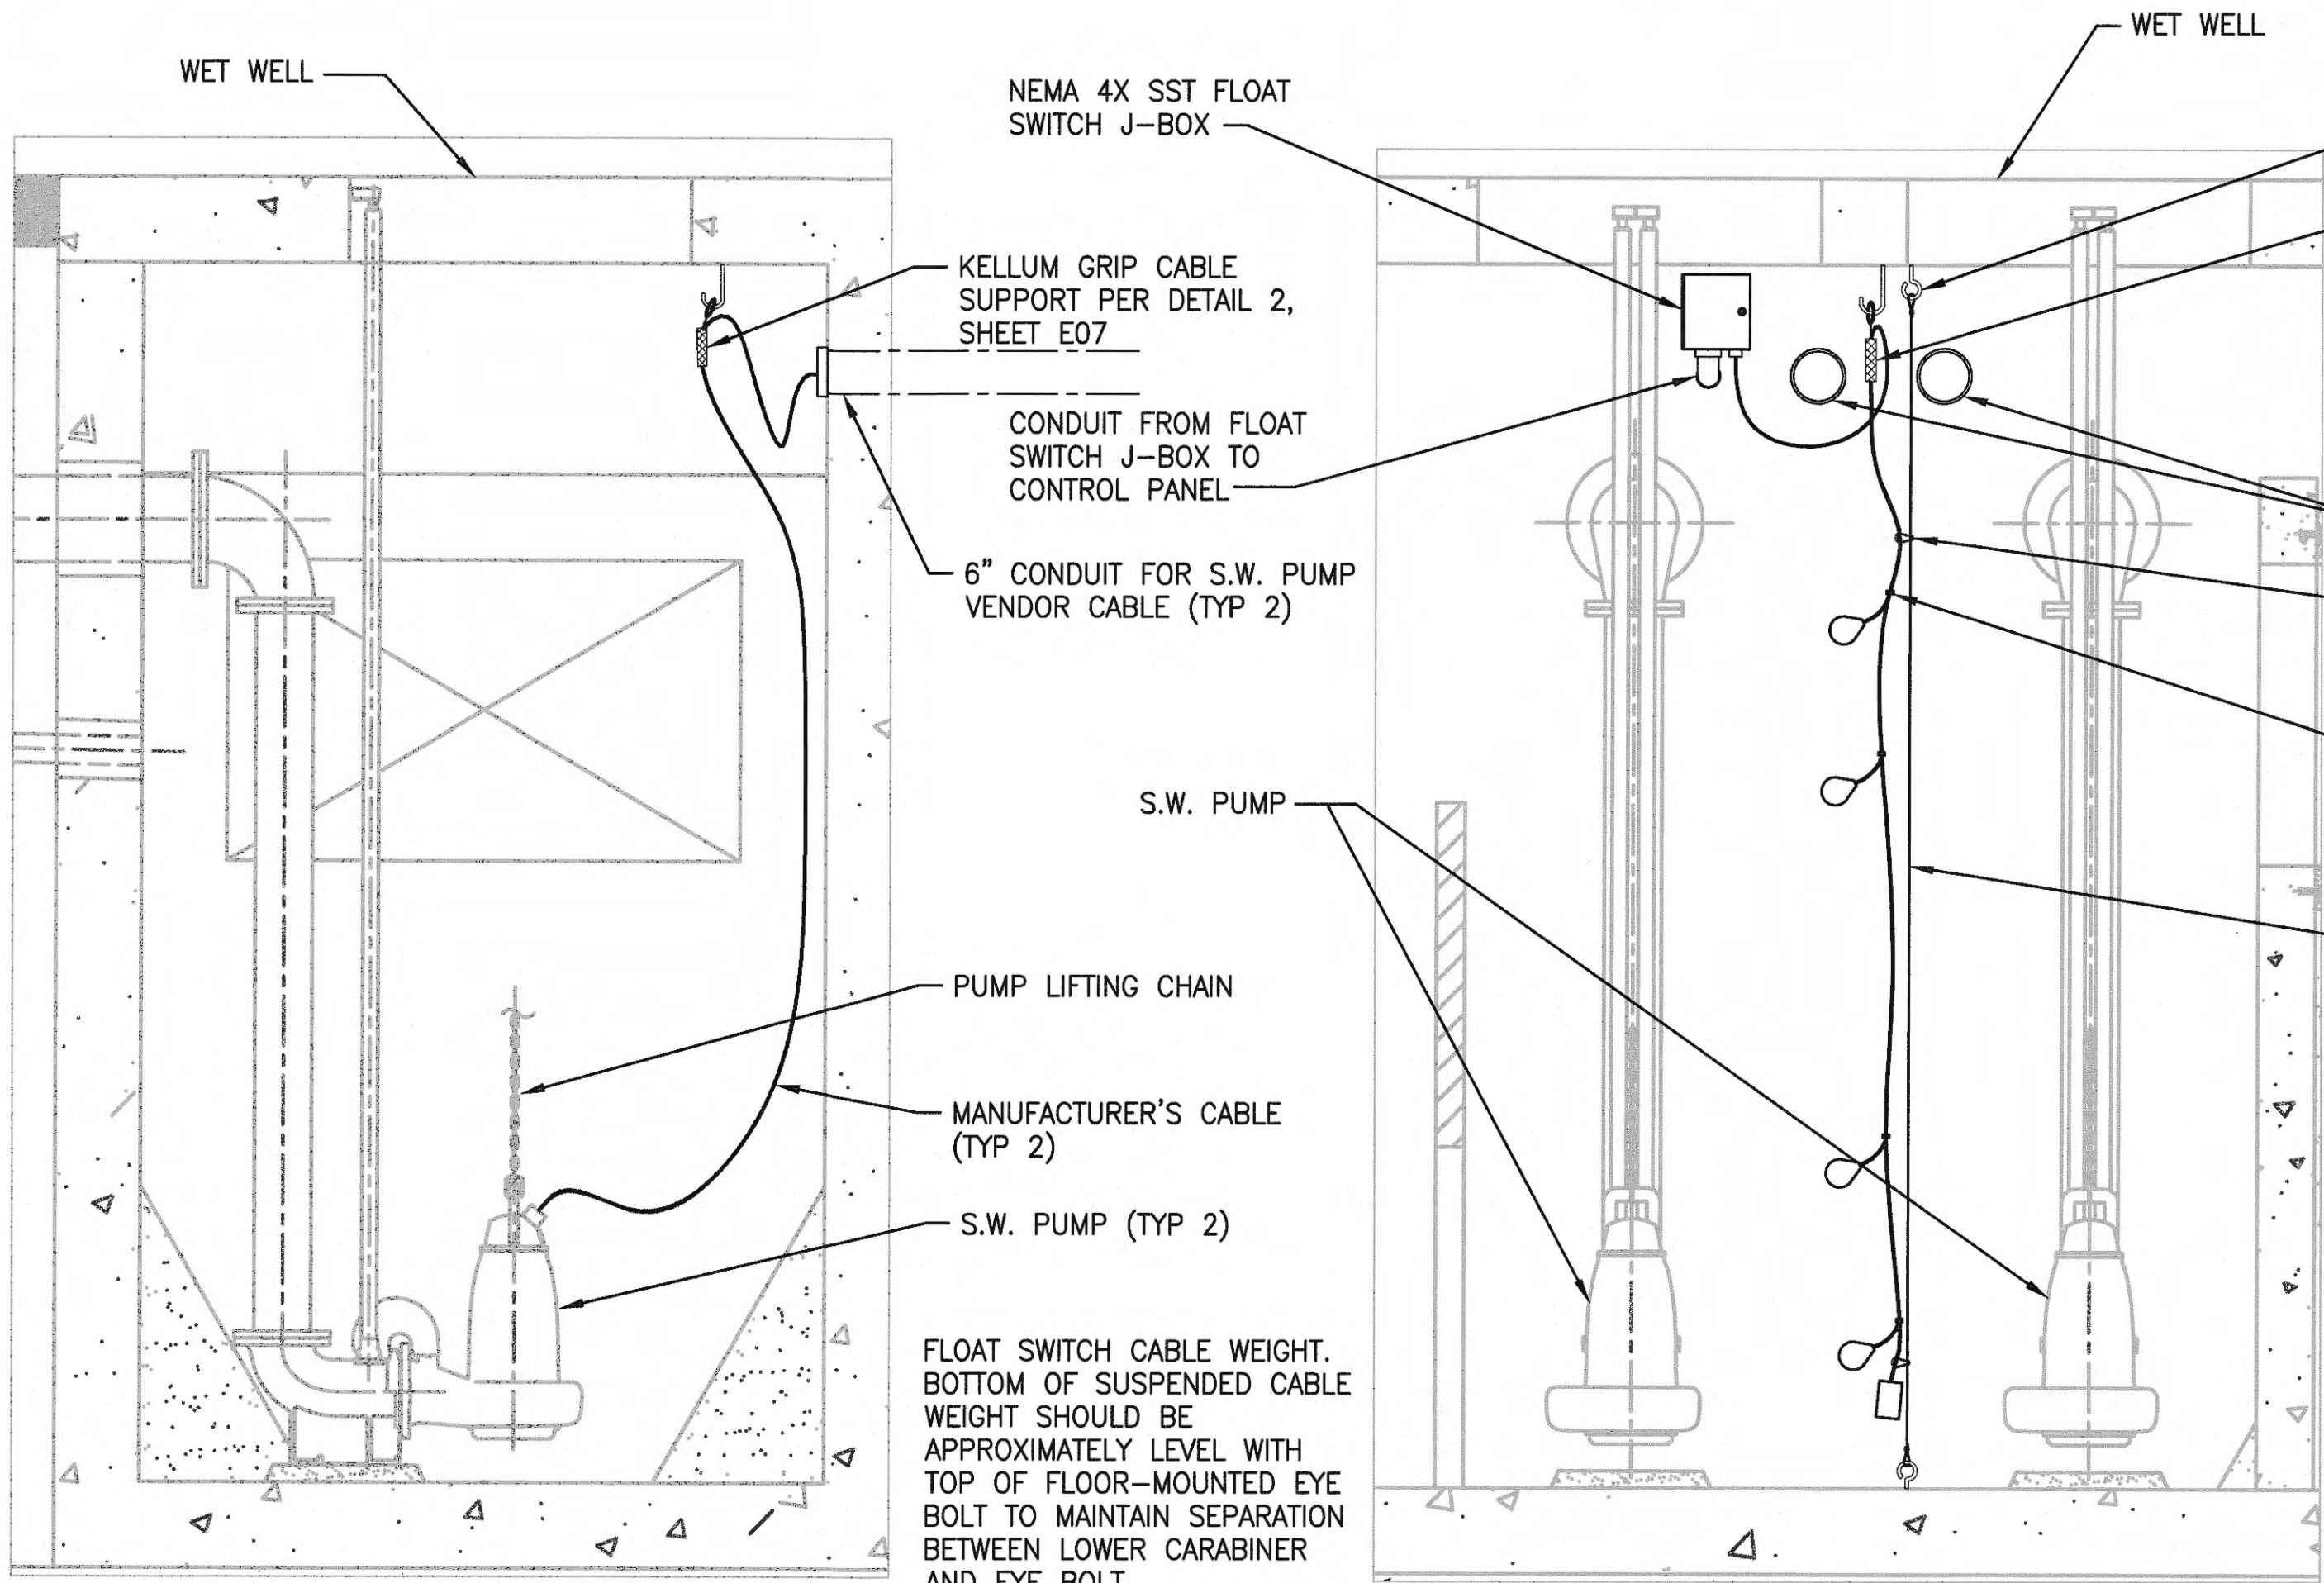

1 PUMP CABLE INSTALLATION DETAIL
SCALE: NOT TO SCALE

2 FLOAT SWITCH INSTALLATION DETAIL
SCALE: NOT TO SCALE

- NOTES:**
- 1. DETAIL IS A TYPICAL ARRANGEMENT. USE THE BASIN ELECTRICAL SITE PLANS TO DETERMINE ACTUAL LOCATIONS OF ELECTRICAL EQUIPMENT.
 - 2. MOUNT FLOAT SWITCH ASSEMBLY IN AN AREA OF LOW TURBULENCE NEAR WALL OR CORNER OF WET WELL.

CONDUIT AND WIRE SCHEDULE							
			CONDUIT	CABLE SIZE & QUANTITY			
NUMBER	FROM	TO	SIZE (")	POWER	CONTROL	SIGNAL	COMMENTS
	MAIN FEEDS						
P-001	EXISTING DISTRIBUTION PANEL	PCP-A1	1-1/4"	3#3,1#8G			
P-002	EXISTING DISTRIBUTION PANEL	PCP-B1	1-1/4"	3#3,1#8G			
P-003	EXISTING DISTRIBUTION PANEL	PCP-C1	2"	3#1,1#6G			
BASIN - A							
P-100	PCP-A1	S.W.PUMP 1 (P-A1)	6"	PUMP PLUG			VENDOR CABLE
P-110	PCP-A1	S.W.PUMP 2 (P-A2)	6"	PUMP PLUG			VENDOR CABLE
P-120	PCP-A1	HEAT TRACE CONTROLLERS	3/4"	2#12, 1#12G			
C-100	PCP-A1	J-BOX A1 (FOR LEVEL SWITCHES)	3/4"		8#14, 1#14G		
C-101	J-BOX-A1	LSLL-A1, LSL-A2, LSH-A3, LSH-A4	3/4"		(4) MFR CABLE		VENDOR CABLE
C-102	PCP-A1	J-BOX A2	3/4"		2#14, 1#14G		
C-103	J-BOX-A2	LSH-A5	3/4"		(1) MFR CABLE		VENDOR CABLE
C-104	PCP-A1	J-BOX-A3	3/4"		2#14, 1#14G		
C-105	J-BOX-A3	LSH-A6	3/4"		(1) MFR CABLE		VENDOR CABLE
BASIN - B							
P-200	PCP-B1	S.W.PUMP 1 (P-B1)	6"	PUMP PLUG			VENDOR CABLE
P-210	PCP-B1	S.W.PUMP 2 (P-B2)	6"	PUMP PLUG			VENDOR CABLE
P-220	PCP-B1	HEAT TRACE CONTROLLERS	3/4"	2#12, 1#12G			
P-230	PCP-B1	HEAT TRACE CONTROLLERS	3/4"	2#12, 1#12G			
C-200	PCP-B1	J-BOX-B1 (FOR LEVEL SWITCHES)	3/4"		8#14, 1#14G		
C-201	J-BOX-B1	LSLL-B1, LSL-B2, LSH-B3, LSH-B4	3/4"		(4) MFR CABLE		VENDOR CABLE
C-202	PCP-B1	J-BOX B2	3/4"		2#14, 1#14G		
C-203	J-BOX-B2	LSH-B5	3/4"		(1) MFR CABLE		VENDOR CABLE
C-204	PCP-B1	J-BOX-B3	3/4"		2#14, 1#14G		
C-205	J-BOX-B3	LSH-B6	3/4"		(1) MFR CABLE		VENDOR CABLE
BASIN - C							
P-300	PCP-C1	S.W.PUMP 1 (P-C1)	6"	PUMP PLUG			VENDOR CABLE
P-310	PCP-C1	S.W.PUMP 2 (P-C2)	6"	PUMP PLUG			VENDOR CABLE
P-320	PCP-C1	HEAT TRACE CONTROLLERS	3/4"	2#12, 1#12G			
P-330	PCP-C1	HEAT TRACE CONTROLLERS	3/4"	2#12, 1#12G			
P-340	PCP-C1	HEAT TRACE CONTROLLERS	3/4"	2#12, 1#12G			
C-300	PCP-C1	J-BOX-C1 (FOR LEVEL SWITCHES)	3/4"		8#14, 1#14G		
C-301	J-BOX-C1	LSLL-C1, LSL-C2, LSH-C3, LSH-C4	3/4"		(4) MFR CABLE		VENDOR CABLE
C-302	PCP-C1	J-BOX-C2	3/4"		2#14, 1#14G		
C-303	J-BOX-C2	LSH-C5	3/4"		(1) MFR CABLE		VENDOR CABLE
C-304	PCP-C1	J-BOX-C3	3/4"		2#14, 1#14G		
C-305	J-BOX-C3	LSH-C6	3/4"		(1) MFR CABLE		VENDOR CABLE

6583

E08

SH 45 OF 47

CONT/CONS: 070664

M. ID: 201024.01

PHASE: BID SET

WEST SITCUM

STORMWATER TREATMENT

ELECTRICAL DETAILS, CONDUIT AND WIRE SCHEDULE

APPROVED: *[Signature]*

AGS MAR 2018

CHECKED BY: JEM

DATE: APR 2018

DIRECTOR: peter den

ENG. DATE: Apr 25, 2018

PRINTED BY: ONE SITCUM PLAZA

TACOMA, WA 98401-1837

RANGE: 3E

TOWNSHIP: 21N

DAT-HRZ: WAB3-S

PARCEL: SEE G02

SECTIONS: 33 & 34

VERT: MLLW

DRAWING SCALE: AS NOTED

Port of Tacoma

ENGINEERING - PLANNING - ENVIRONMENTAL SCIENCES

600 WASHINGTON AVENUE, SUITE 390

SEASIDE, WA 98137

WWW.PARAMETRIX.COM

MARK: REVISION:



BY:

DATE:

THIS DRAWING IS THE PROPERTY OF THE PORT OF TACOMA AND SHALL NOT BE USED ON OTHER WORK, DISCLOSED, COPIED, IN WHOLE OR IN PART, WITHOUT WRITTEN PERMISSION

PORT OF TACOMA FILE: U:\PSO\Projects\Clients\8001-NW Seaport Alliance\553-8001-001 West Sitcum\99Svc\CA\DD\WG\PS8001001E-09


BINDING EDGE

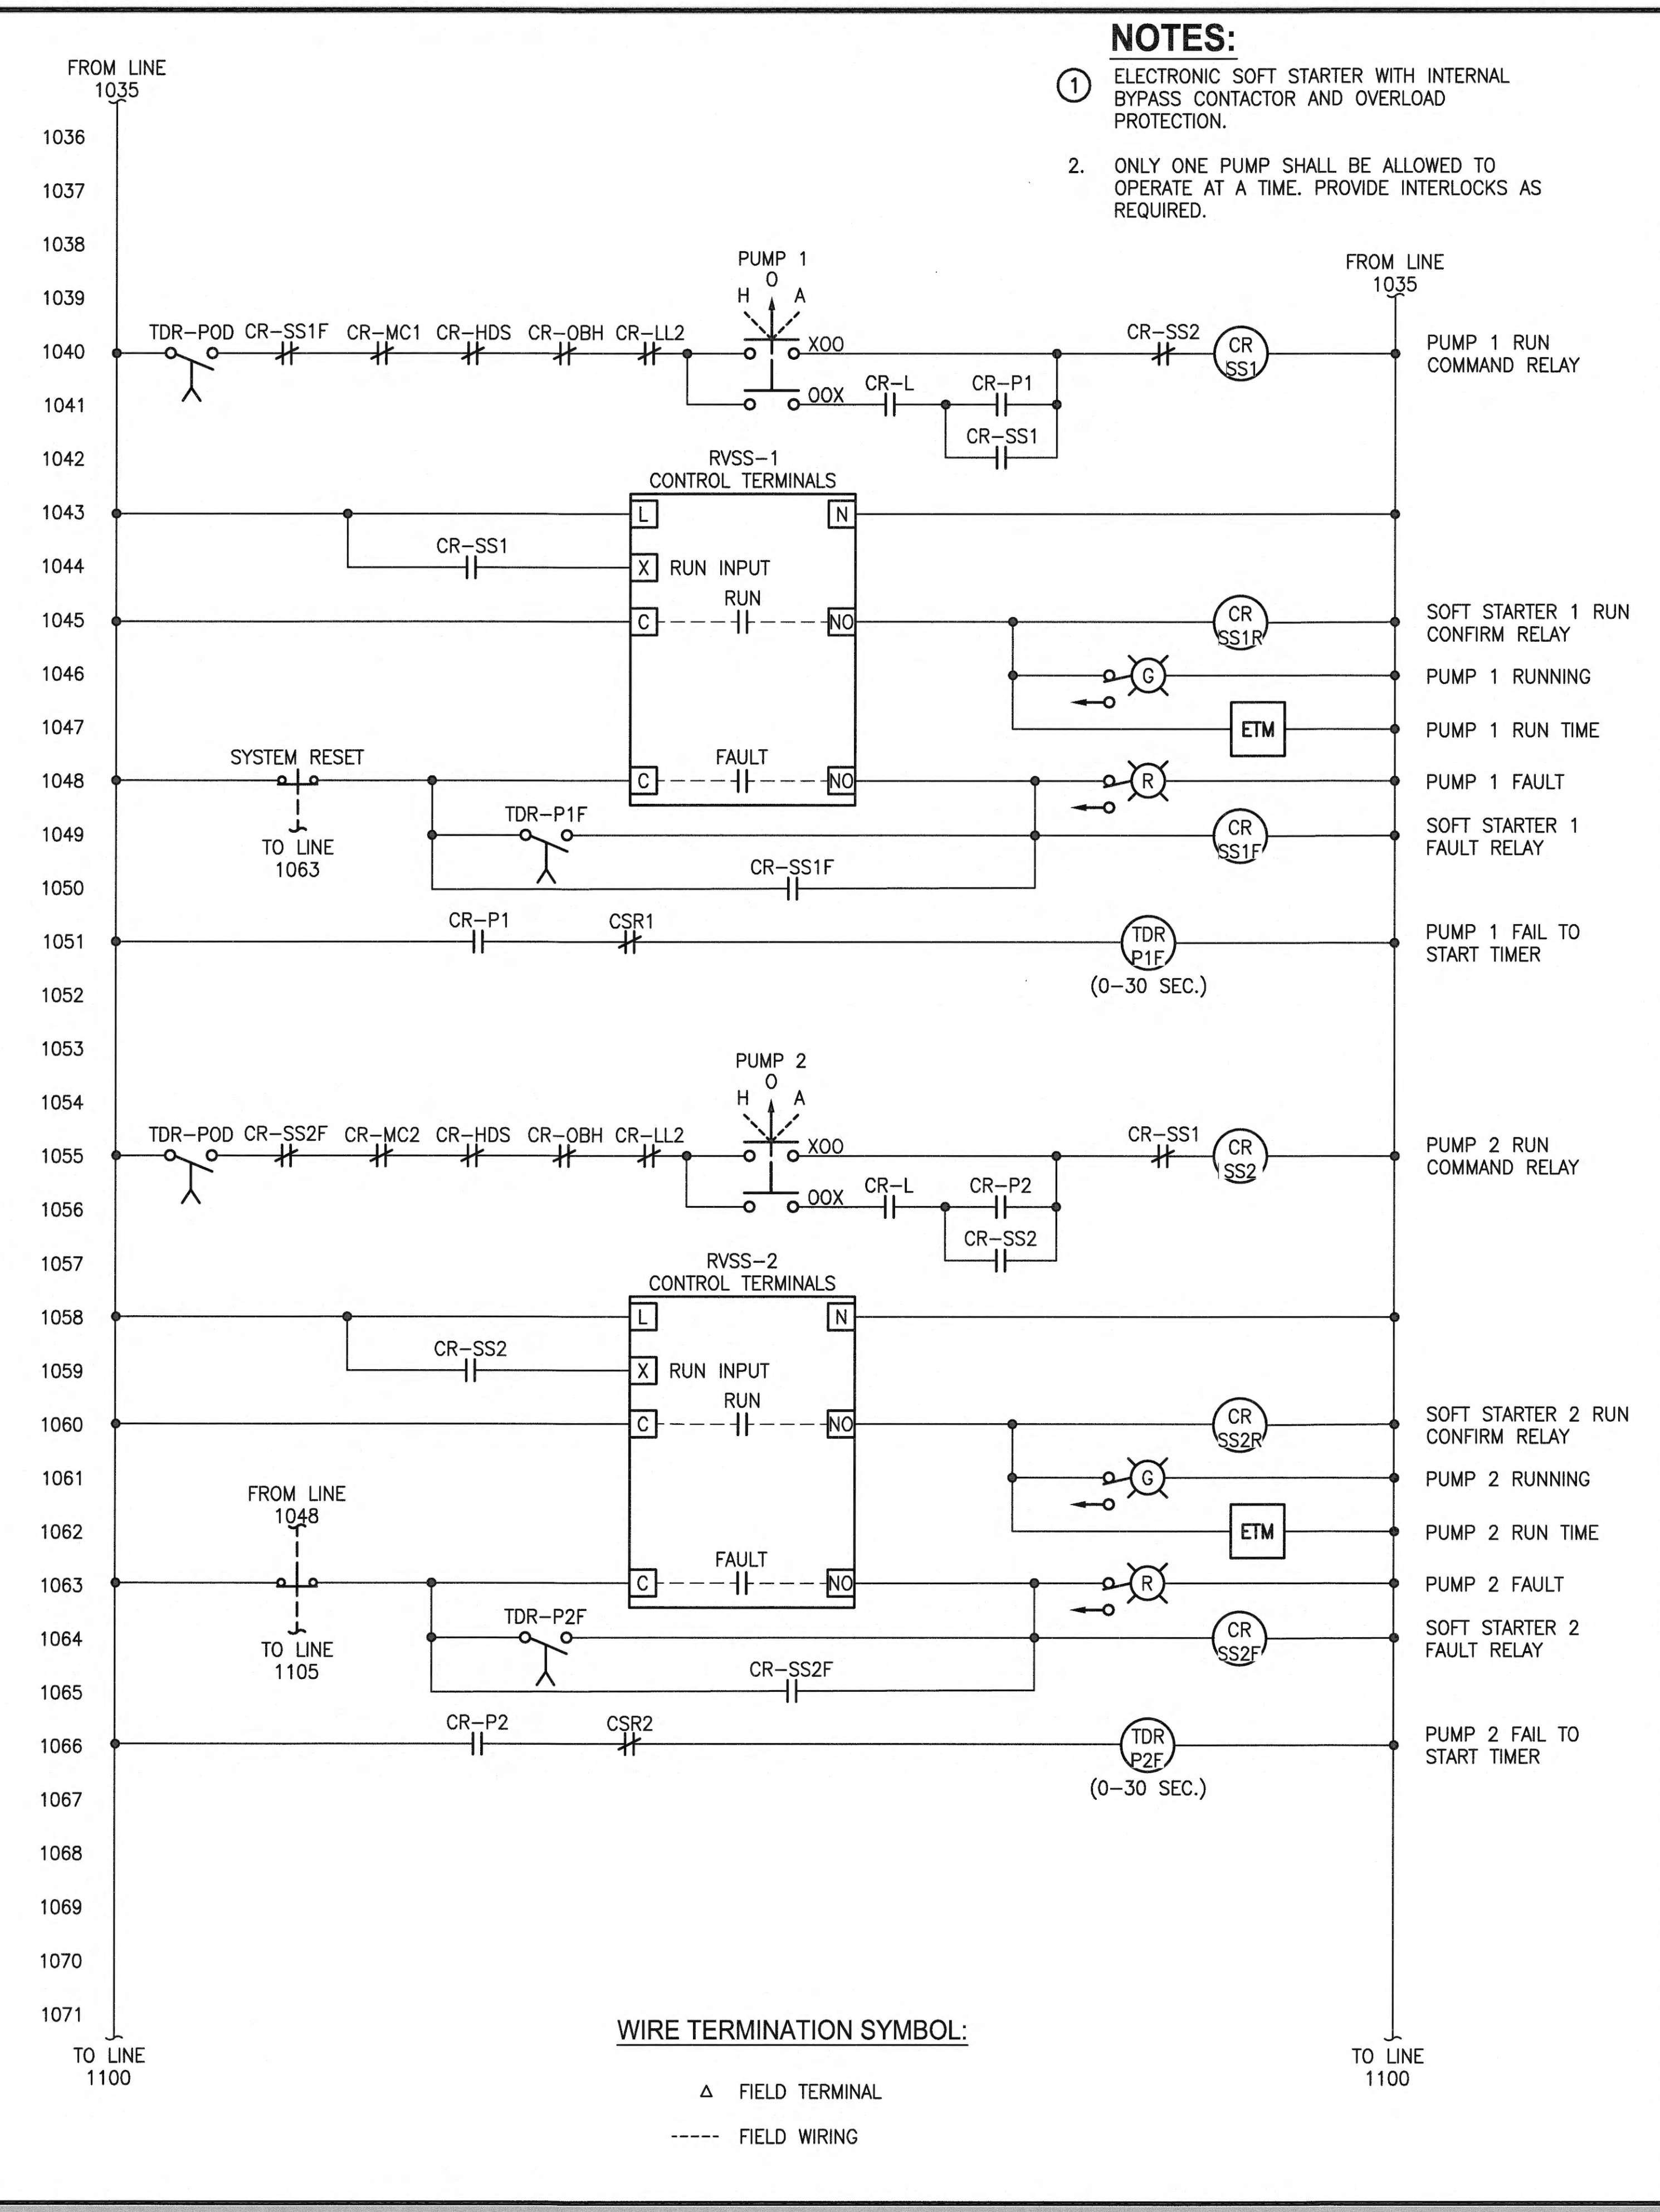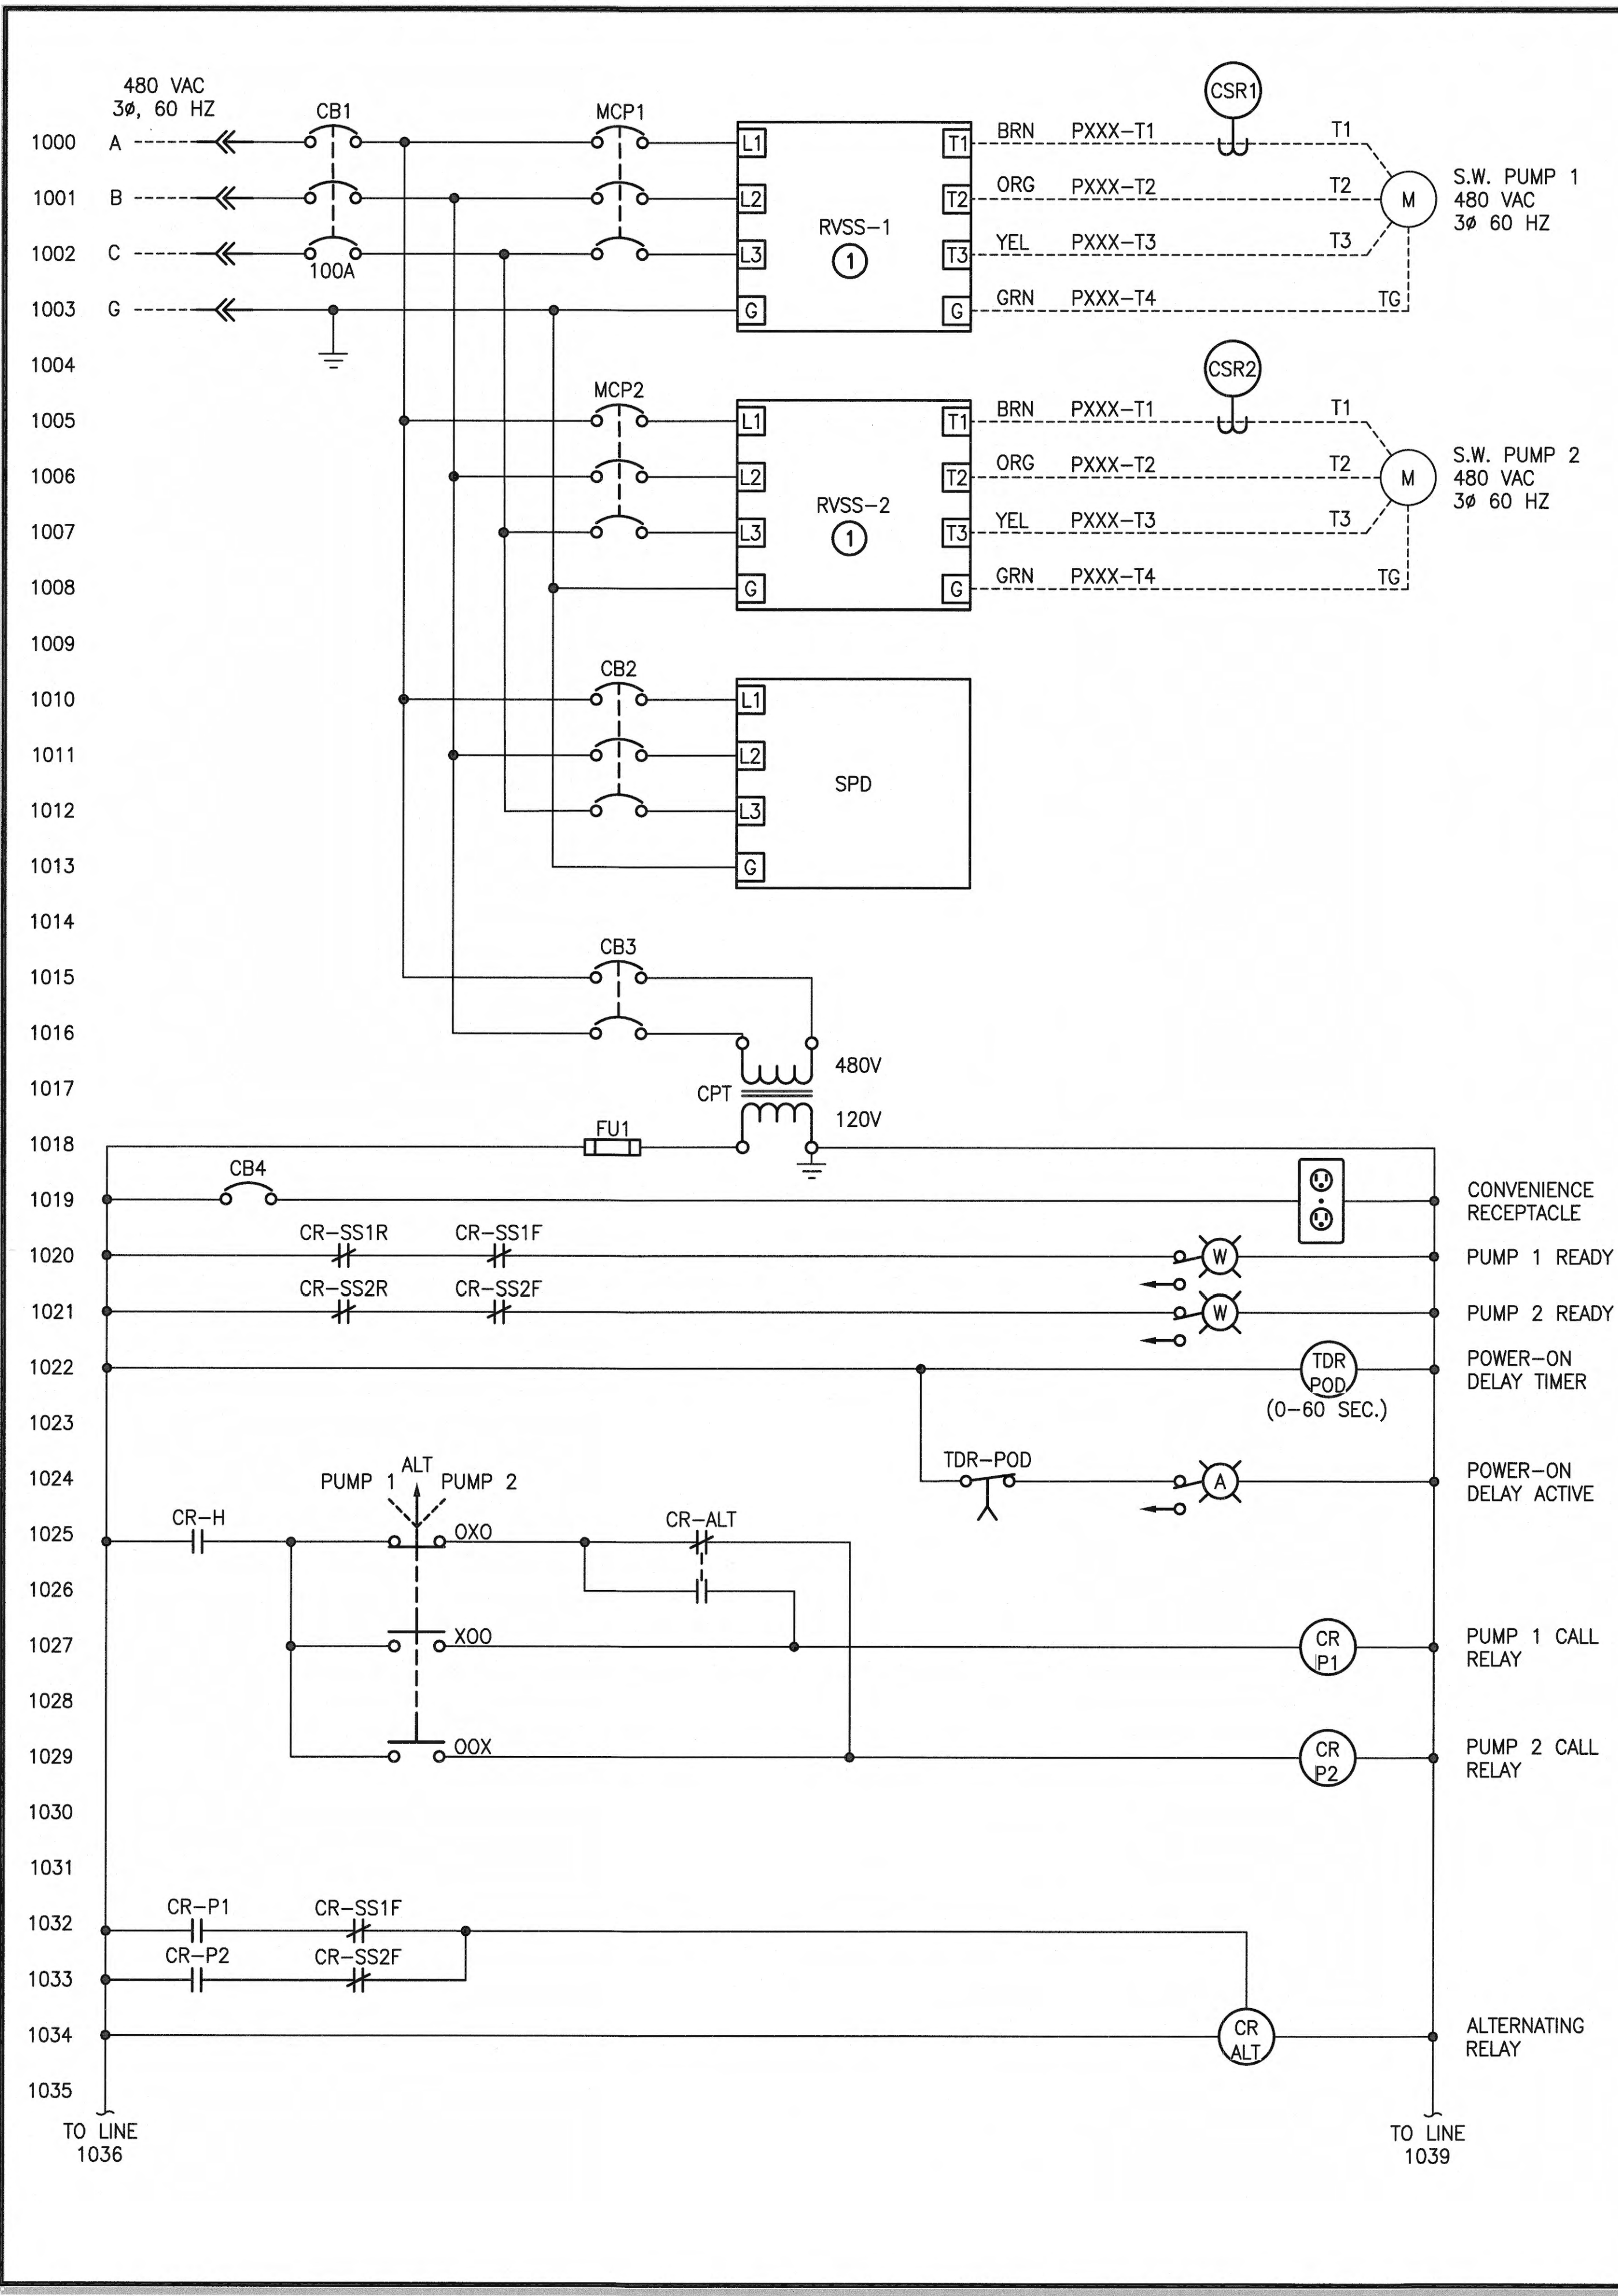


- NOTES:**
1. ELECTRONIC SOFT STARTER WITH INTERNAL BYPASS CONTACTOR AND OVERLOAD PROTECTION.
 2. ONLY ONE PUMP SHALL BE ALLOWED TO OPERATE AT A TIME. PROVIDE INTERLOCKS AS REQUIRED.

6583 E09 SH 46 OF 47	WEST SITCUM STORMWATER TREATMENT ELEMENTARY DIAGRAMS		APPROVED: <i>[Signature]</i> DIRECTOR		AGS MAR 2018	CHECKED BY DATE	DATE
	TOWNSHIP: 21N RANGE: 3E SECTION: 33 & 34		PRINTED BY: <i>[Signature]</i> DATE		JEM APR 2018	PROJ. ENGR DATE	DATE
	M. ID: 201024.01		PORT ADDRESS: ONE SITCUM PLAZA		TACOMA, WA 98401-1837		
	PHASE: BID SET		DRAWING SCALE: AS NOTED				

THIS DRAWING IS THE PROPERTY OF THE PORT OF TACOMA AND SHALL NOT BE USED ON OTHER WORK, DISCLOSED, COPIED, IN WHOLE OR IN PART, WITHOUT WRITTEN PERMISSION

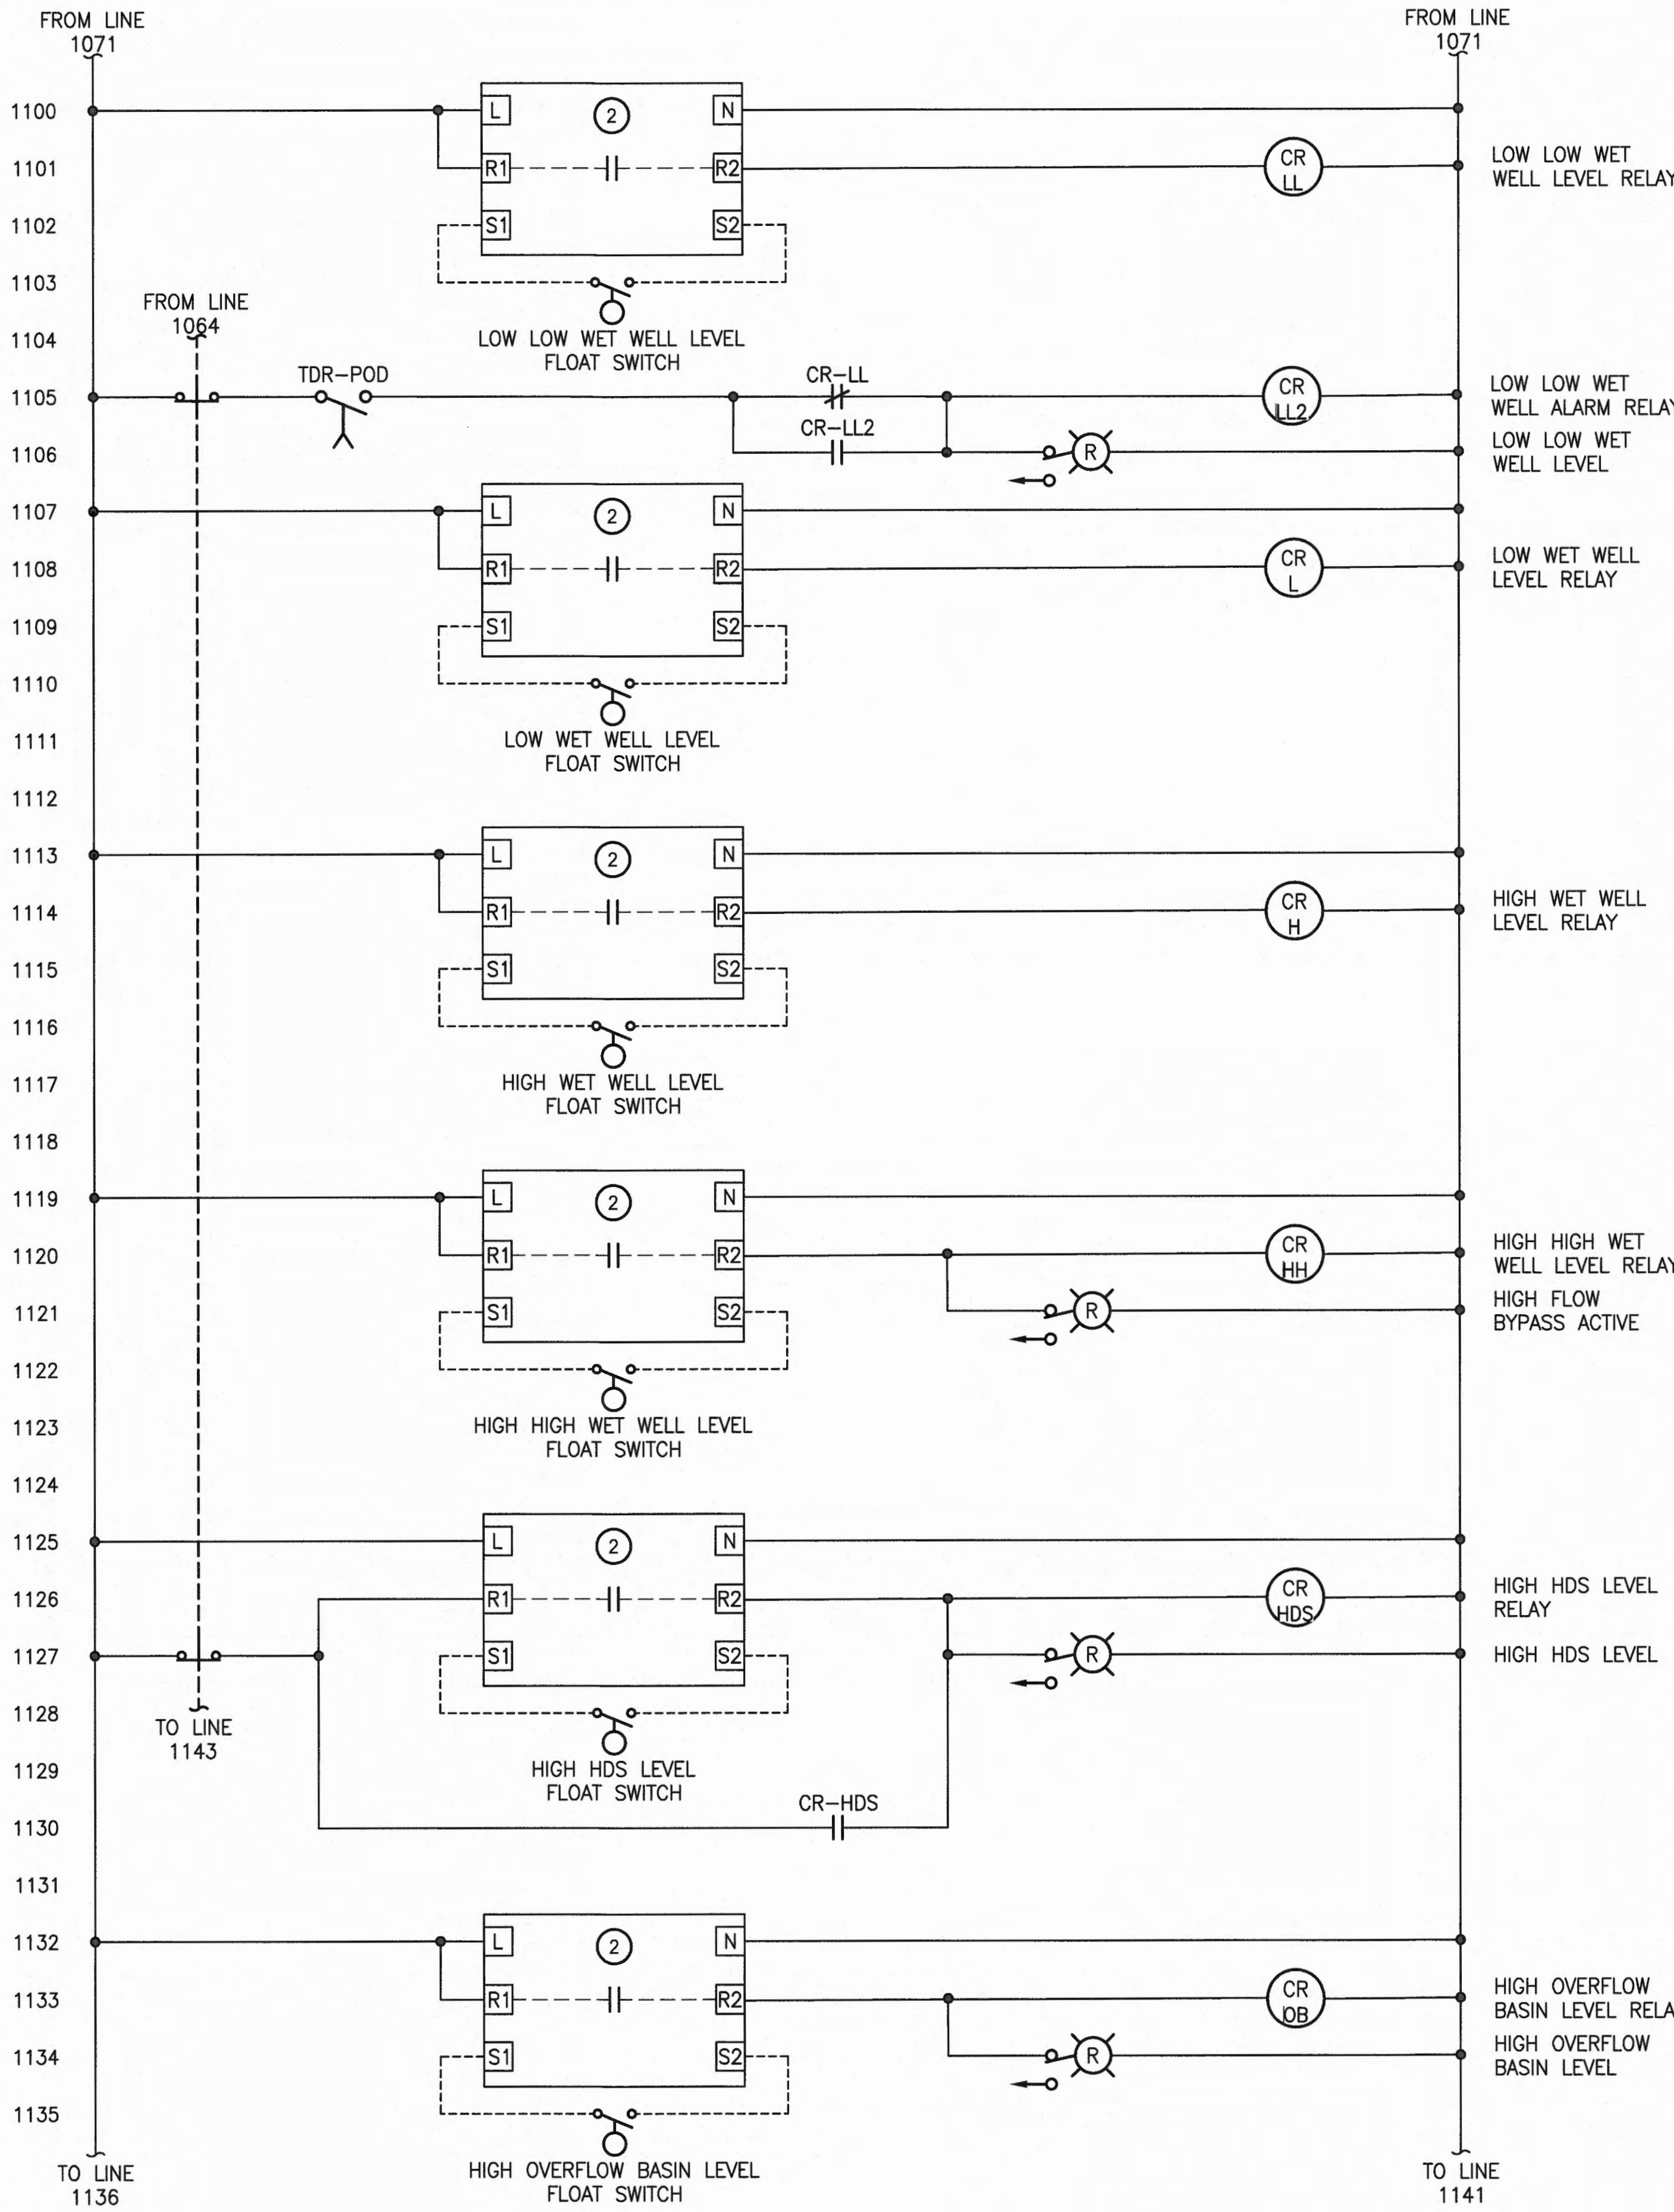

- NOTES:**
- 1 RELAY COMBINING MOISTURE AND OVERTEMP SENSORS. SEAL LEAKAGE, OVERTEMPERATURE, AND POWER AVAILABLE INDICATOR LIGHTS SHALL BE PROVIDED INTEGRAL TO UNIT. UNIT TO BE SUPPLIED LOOSE WITH PUMPS FOR INSTALLATION INTO CONTROL PANEL.
 - 2 INTRINSICALLY SAFE RELAY.
 - 3 PROVIDE CIRCUIT BREAKER FOR HEAT TRACE CIRCUITS WITH GROUND FAULT PROTECTION PER NEC REQUIREMENTS. MULTIPLE HEAT TRACE CONTROLLERS AND CIRCUITS MAY BE REQUIRED. SEE DRAWINGS E04, E06, AND E08.

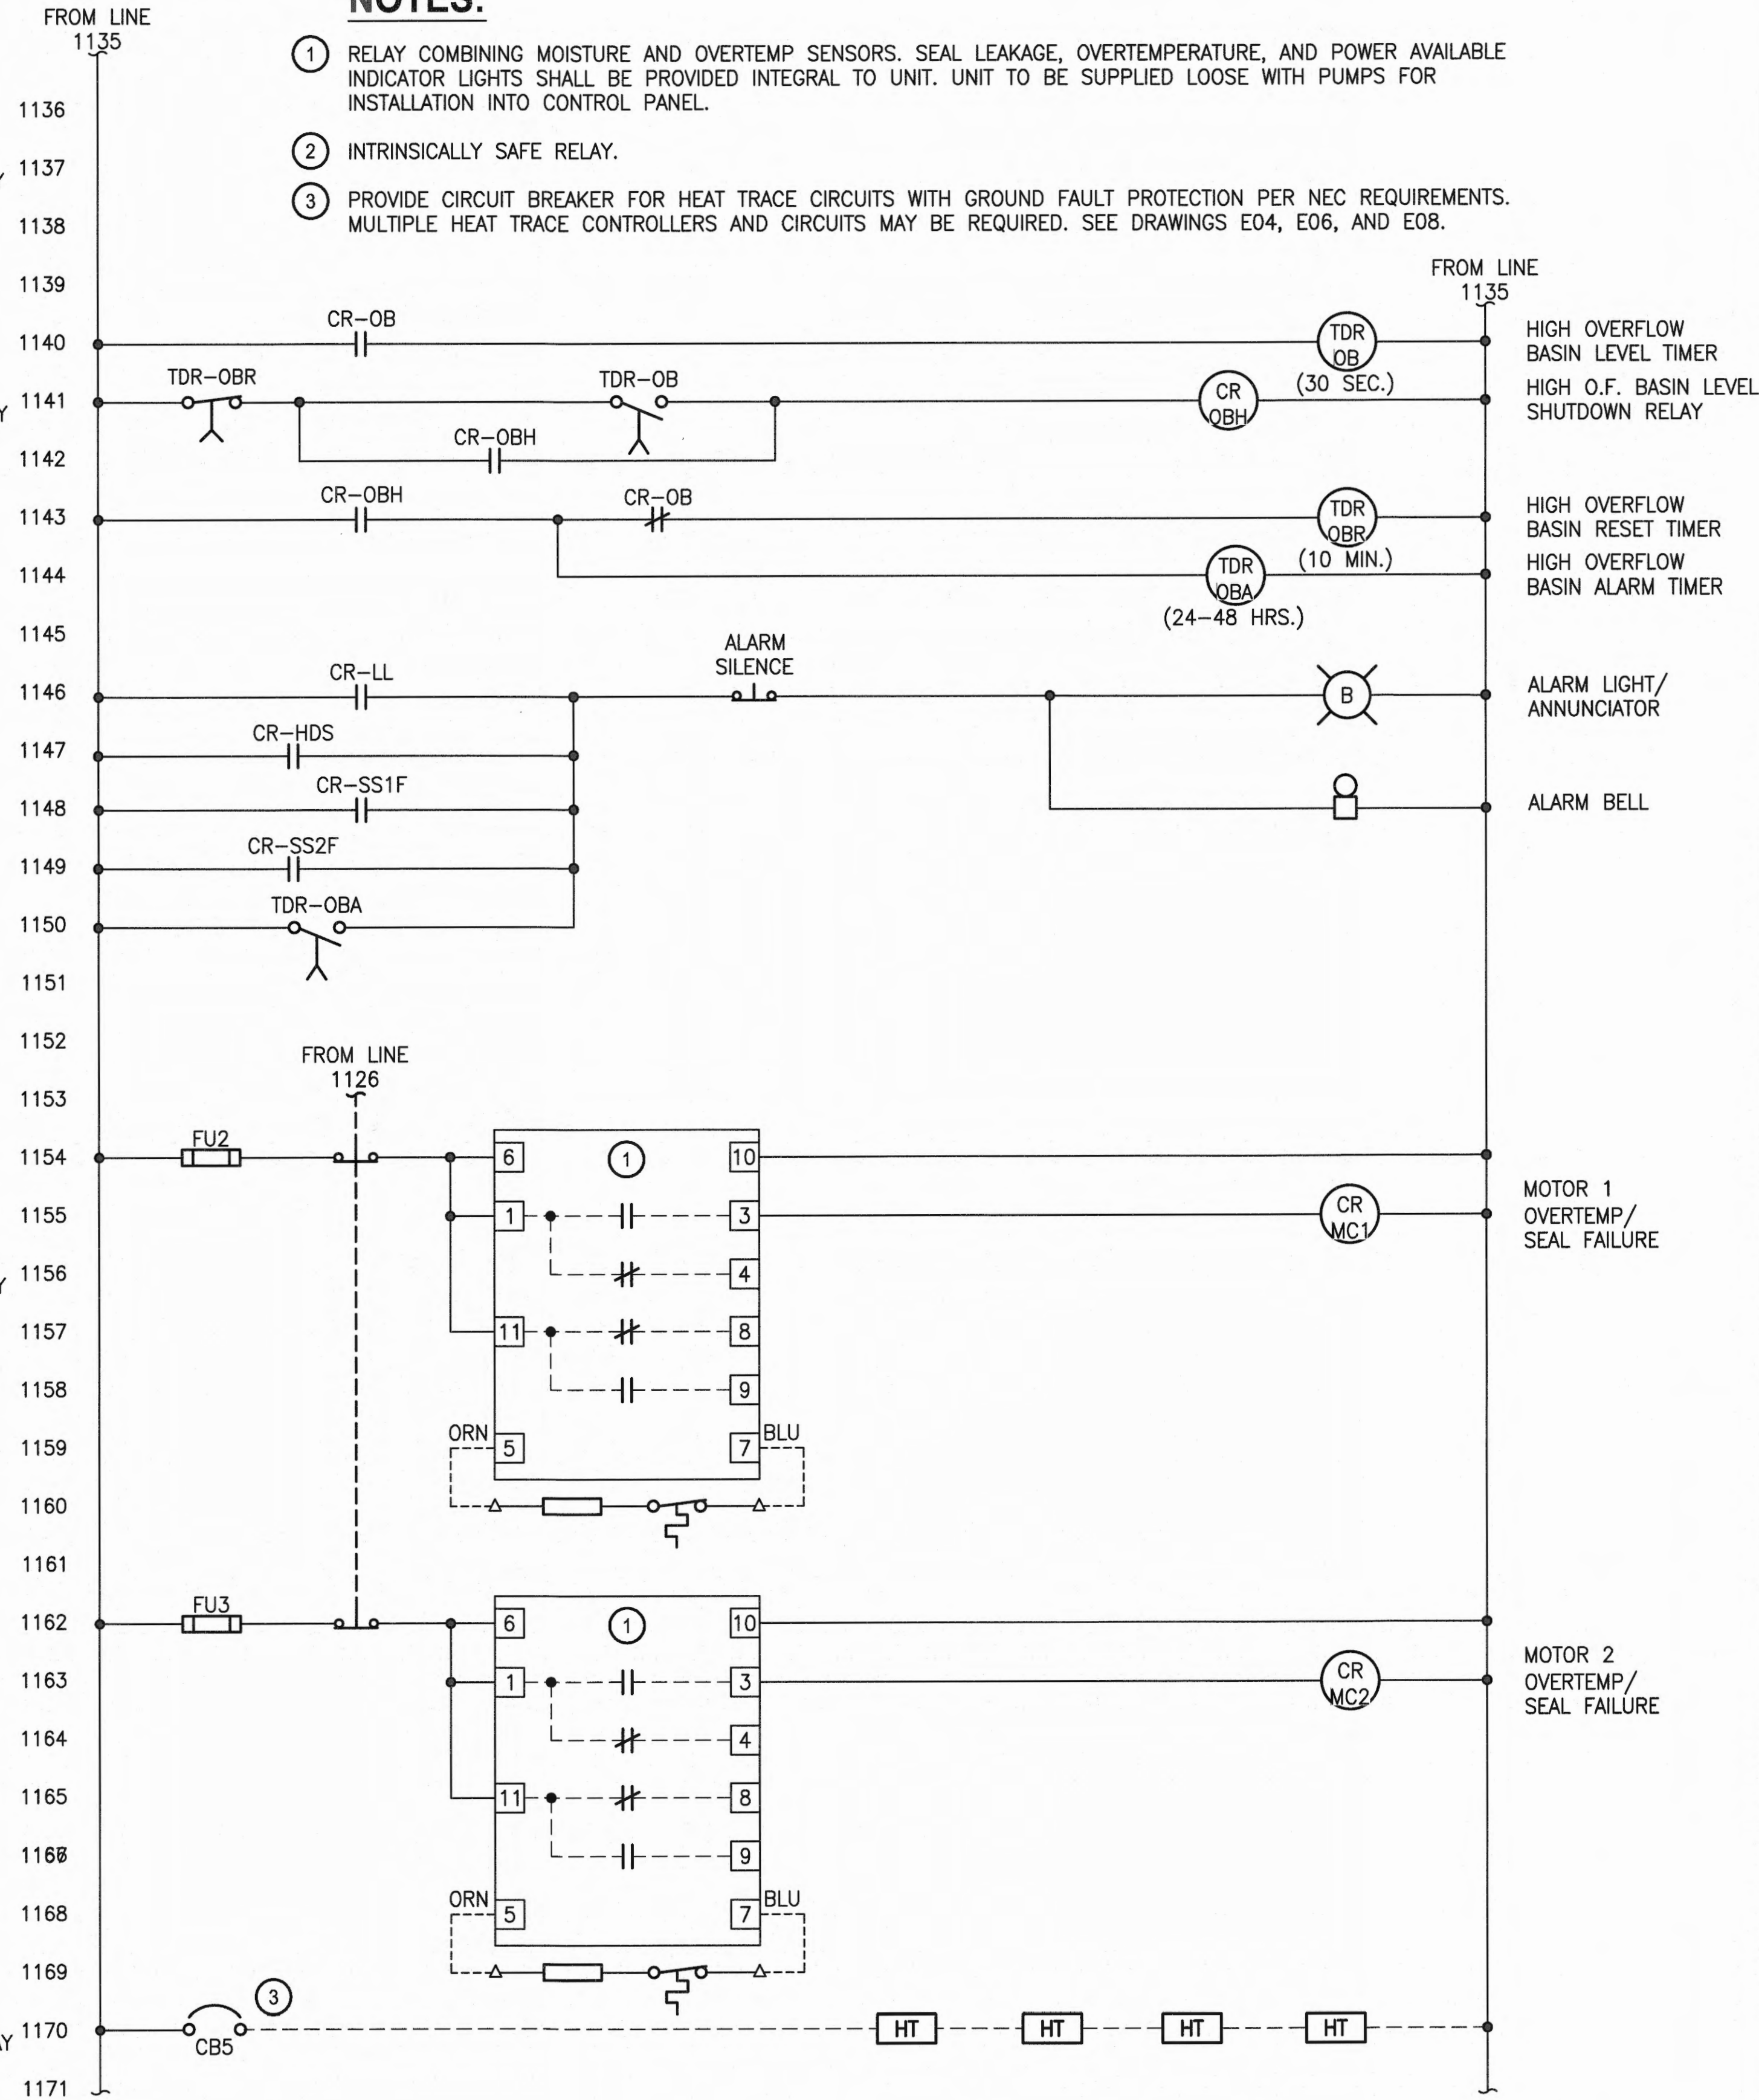

WIRE TERMINATION SYMBOL:
△ FIELD TERMINAL
---- FIELD WIRING

Port of Tacoma
P.O. BOX 1837 TACOMA, WA 98401-1837

Parametrix
ENGINEERING, ARCHITECTURE, ENVIRONMENTAL SCIENCES
80 WASHINGTON AVENUE, SUITE 350
PACIFIC, WA 98044
WWW.PARAMETRIX.COM

SEAL OF THE PORT OF TACOMA
TACOMA, WA
APRIL 25, 2018

CHECKED BY: DATE

PROJ. ENGR: DATE

APPROVED: DATE

4/26/18

4/26/18

4/26/18

4/26/18

4/26/18

4/26/18

WEST SITCUM
STORMWATER TREATMENT
ELEMENTARY DIAGRAMS

6583
SH 47 OF 47
E10

TOWNSHIP: 21N
RANGE: 3E
SECTION: 33 & 34
DATE-HRZ: WA83-S
PARCEL: SEE G02

PRINTED BY: peterden Apr 25, 2018

PORT ADDRESS: ONE SITCUM PLAZA

DRAWING SCALE: AS NOTED

CONTRACT/CONS: 070664

M. ID: 201024.01

PHASE: BID SET

THIS DRAWING IS THE PROPERTY OF THE PORT OF TACOMA AND SHALL NOT BE USED ON OTHER WORK, DISCLOSED, COPIED, IN WHOLE OR IN PART, WITHOUT WRITTEN PERMISSION

APRIL 25, 2018